




5TH & BROAD
CONSTRUCTION DOCUMENTS
VOLUME 1

Paper Architecture
 110 W. 8th, Portland, OR 97214
 P 503.523.0001 F 503.523.7195





- NOTES**
1. ALL PAVEMENT MARKINGS AND SIGNAGE SHALL BE INSTALLED PER MUTCD.
 2. ARCHITECTURAL AND LANDSCAPE PLANS ARE SHOWN FOR REFERENCE ONLY.
 3. CONTRACTOR TO REFER TO THE GEOTECHNICAL REPORT FOR THIS SITE WHICH SHALL BE CONSIDERED PART OF THE PROJECT DOCUMENTS.
 4. ALL CLEAN-OUTS TO BE INSTALLED FLUSH WITH FINISHED GRADE.
 5. ALL CLEAN-OUTS INSTALLED IN THE ALLEY TO BE TRAFFIC RATED.
 6. EXISTING SEEPAGE BED IN PARKING LOT ADJACENT TO W. BROAD ST. TO BE REMOVED AND RE-COMPACTED IN ACCORDANCE WITH ISPMC SECTION 306-TYPE A-1 BACKFILL.
 7. CONTRACTOR TO CONTACT BOISE PUBLIC WORKS 48 HOURS PRIOR TO CAPPING EXISTING SEWER SERVICES OR CONNECTING NEW SERVICES TO THE SEWER MAIN TO SCHEDULE AN INSPECTION AND OBTAIN PLUG/TAP PERMITS.

- KEYNOTES**
1. UTILITY TO BE INSTALLED WITHIN SILVA CELL STORM DRAINAGE FACILITY. REFER TO MANUFACTURER'S RECOMMENDATIONS FOR INSTALLATION.
 2. EXISTING CENTURY LINK FIBER OPTIC LINE. CONTRACTOR TO COORDINATE WITH CENTURY LINK TO PROTECT/RELOCATE BASED ON CONFLICTS WITH STORM DRAINAGE FACILITY AND LANDSCAPING REQUIREMENTS.
 3. SAWCUT EXISTING ASPHALT FOR UTILITY/CONCRETE WORK. ASPHALT PATCH PER ACHD SD-303. SEE ROADWAY SECTIONS ON SHEET 5 FOR DETAILS.
 4. EXISTING SEWER SERVICE TO BE CAPPED AND ABANDONED.

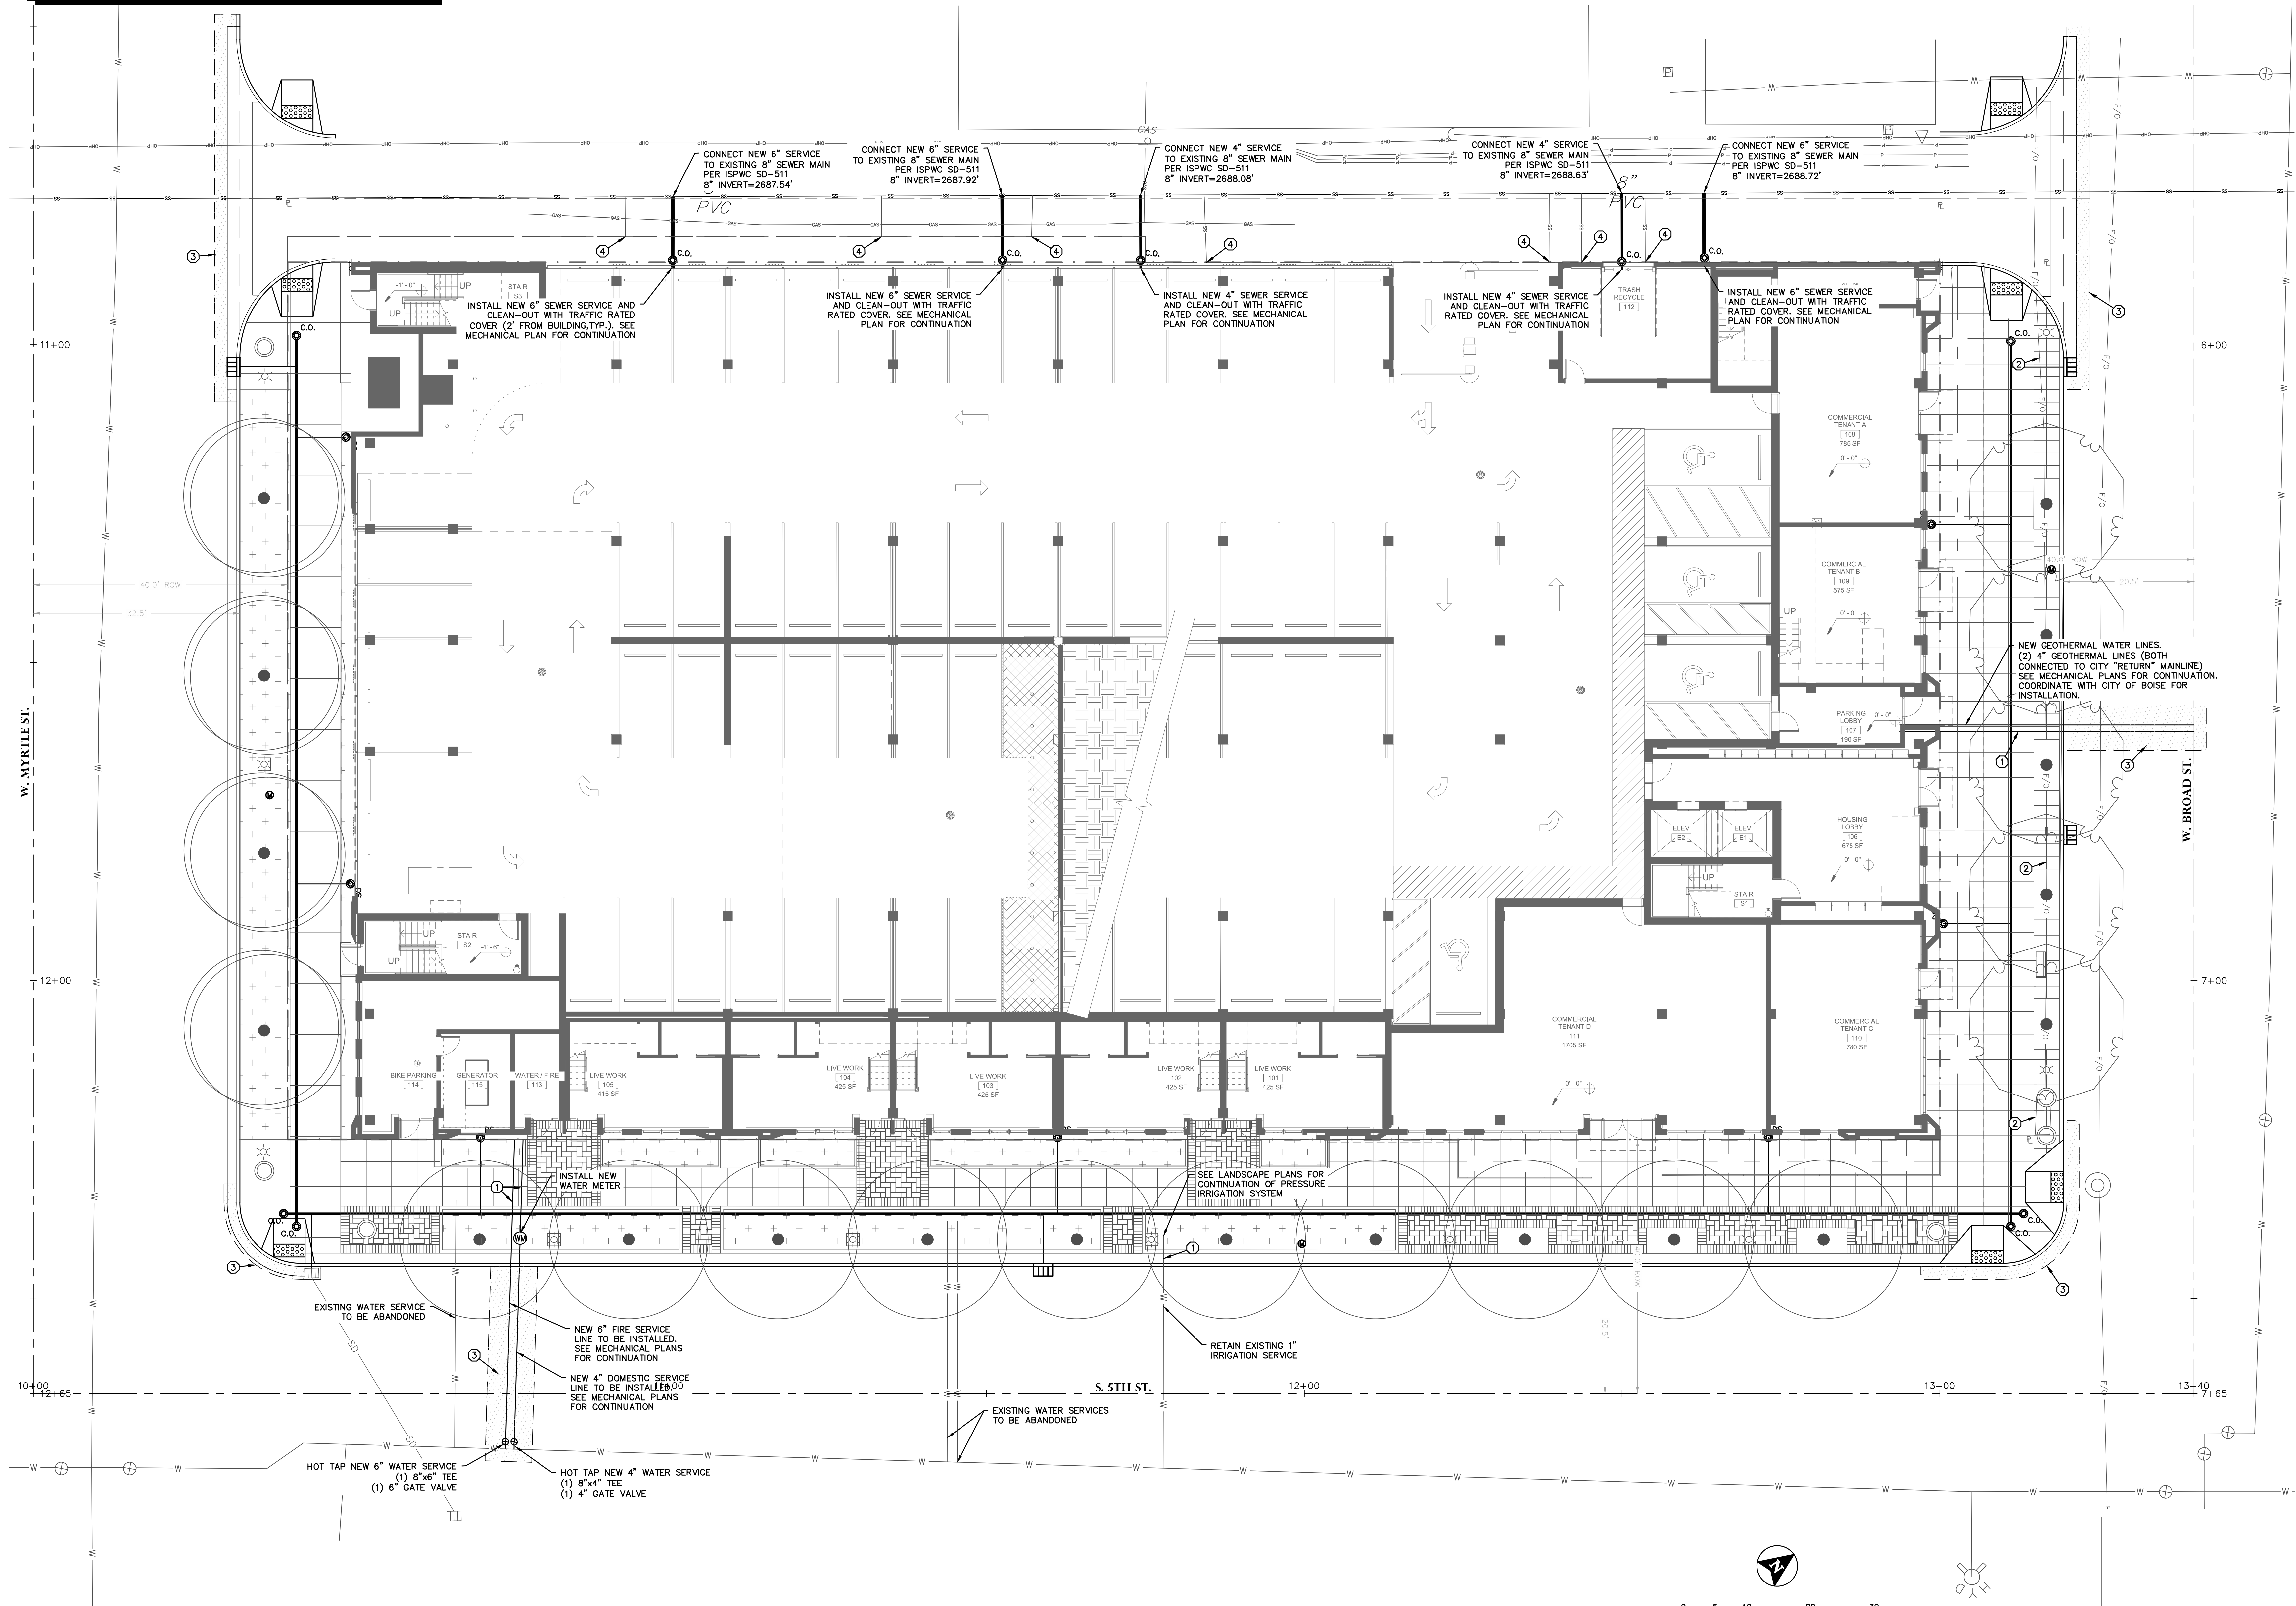

MASTER UTILITY PLAN

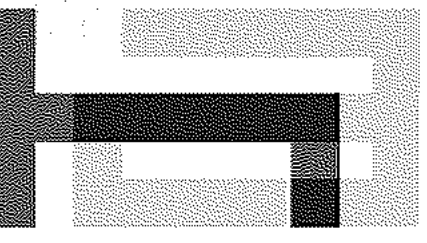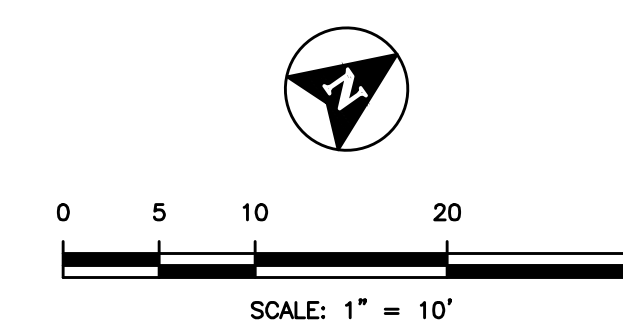


Holst Architecture

110 SE 8th Ave
Portland, OR 97214
www.holstarc.com

5TH & BROAD

401 S 5TH ST
BOISE, ID 83702

JOB NO. HA-14-111
TO: 150033

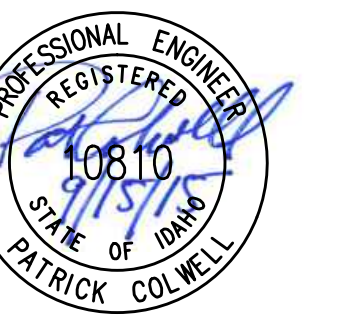

T-O ENGINEERS
332 N. BROADMORE WAY
NAMPA, IDAHO 83687-5123

PHONE: (208) 442-6300 FAX: (208) 466-0944

PODIUM PERMIT

06.12.15

ISSUE:	DATE:
100% SD	04.14.15
PODIUM PERMIT	06.12.15
100% DD	07.09.15
50% CD	08.20.15
60% CD	09.08.15
75% CD PERMIT	09.18.15

revision list date:

sheet title:

MASTER
UTILITY PLAN

sheet no.:

C1.02

© 2012 HOLST ARCHITECTURE pc

NOTES


1. CONTRACTOR TO CONTACT DEEPROOT AND T-O ENGINEERS TO SCHEDULE ON-SITE SUPERVISION PRIOR TO BEGINNING SILVA CELL INSTALLATION. FIVE WORKING DAYS NOTICE IS REQUIRED TO SCHEDULE ON-SITE SUPERVISION. CONTACT PAT GREENLEY (DEEPROOT) AT 612-840-9004. CONTACT PAT COLWELL (T-O ENGINEERS) AT 442-8300.
2. CONTRACTOR TO CONTACT PROJECT GEOTECHNICAL ENGINEER FOR COMPACTION TESTING AND SUBGRADE INSPECTION PRIOR TO SILVA CELL INSTALLATION.
3. INSTALL SILVA CELL2 PER SILVA CELL SPECIFICATION AND MANUFACTURER INSTALLATION INSTRUCTIONS.
4. MATERIAL EXCAVATED FOR SILVA CELL INSTALLATION SHALL BE DISPOSED OFF-SITE.
5. INSTALL SILVA CELL2 FRAMES AROUND, OVER, OR UNDER EXISTING AND PROPOSED UTILITIES.
6. ARCHITECTURAL AND LANDSCAPE PLANS ARE SHOWN FOR REFERENCE ONLY.

KEYNOTES


1. INSTALL TYPE I CATCH BASIN PER ACHD SD-601. SEE DETAIL 5, SHEET 5. REPLACE CURB AND ASPHALT AS NEEDED.
2. CONNECT NEW STORM DRAIN PIPE TO EXISTING CATCH BASIN. SEE DETAIL 6, SHEET 5.
3. CONNECT 4" SOLID WALL DOWNSPOUT PIPE TO 6" PERFORATED PIPE. SEE MECHANICAL PLANS FOR LOCATION.
4. 6" ADS PERFORATED PIPE
5. INSTALL MONITORING WELL. SEE DETAIL 9, SHEET 5.
6. INSTALL TRAFFIC RATED CLEAN-OUT. SEE DETAIL 11, SHEET 5.
7. INSTALL 6" SDR-35 CROSS CONNECTION

SILVA CELLS

461 - 3 STACK SILVA2 CELL UNITS SHOWN ON THIS LAYOUT.

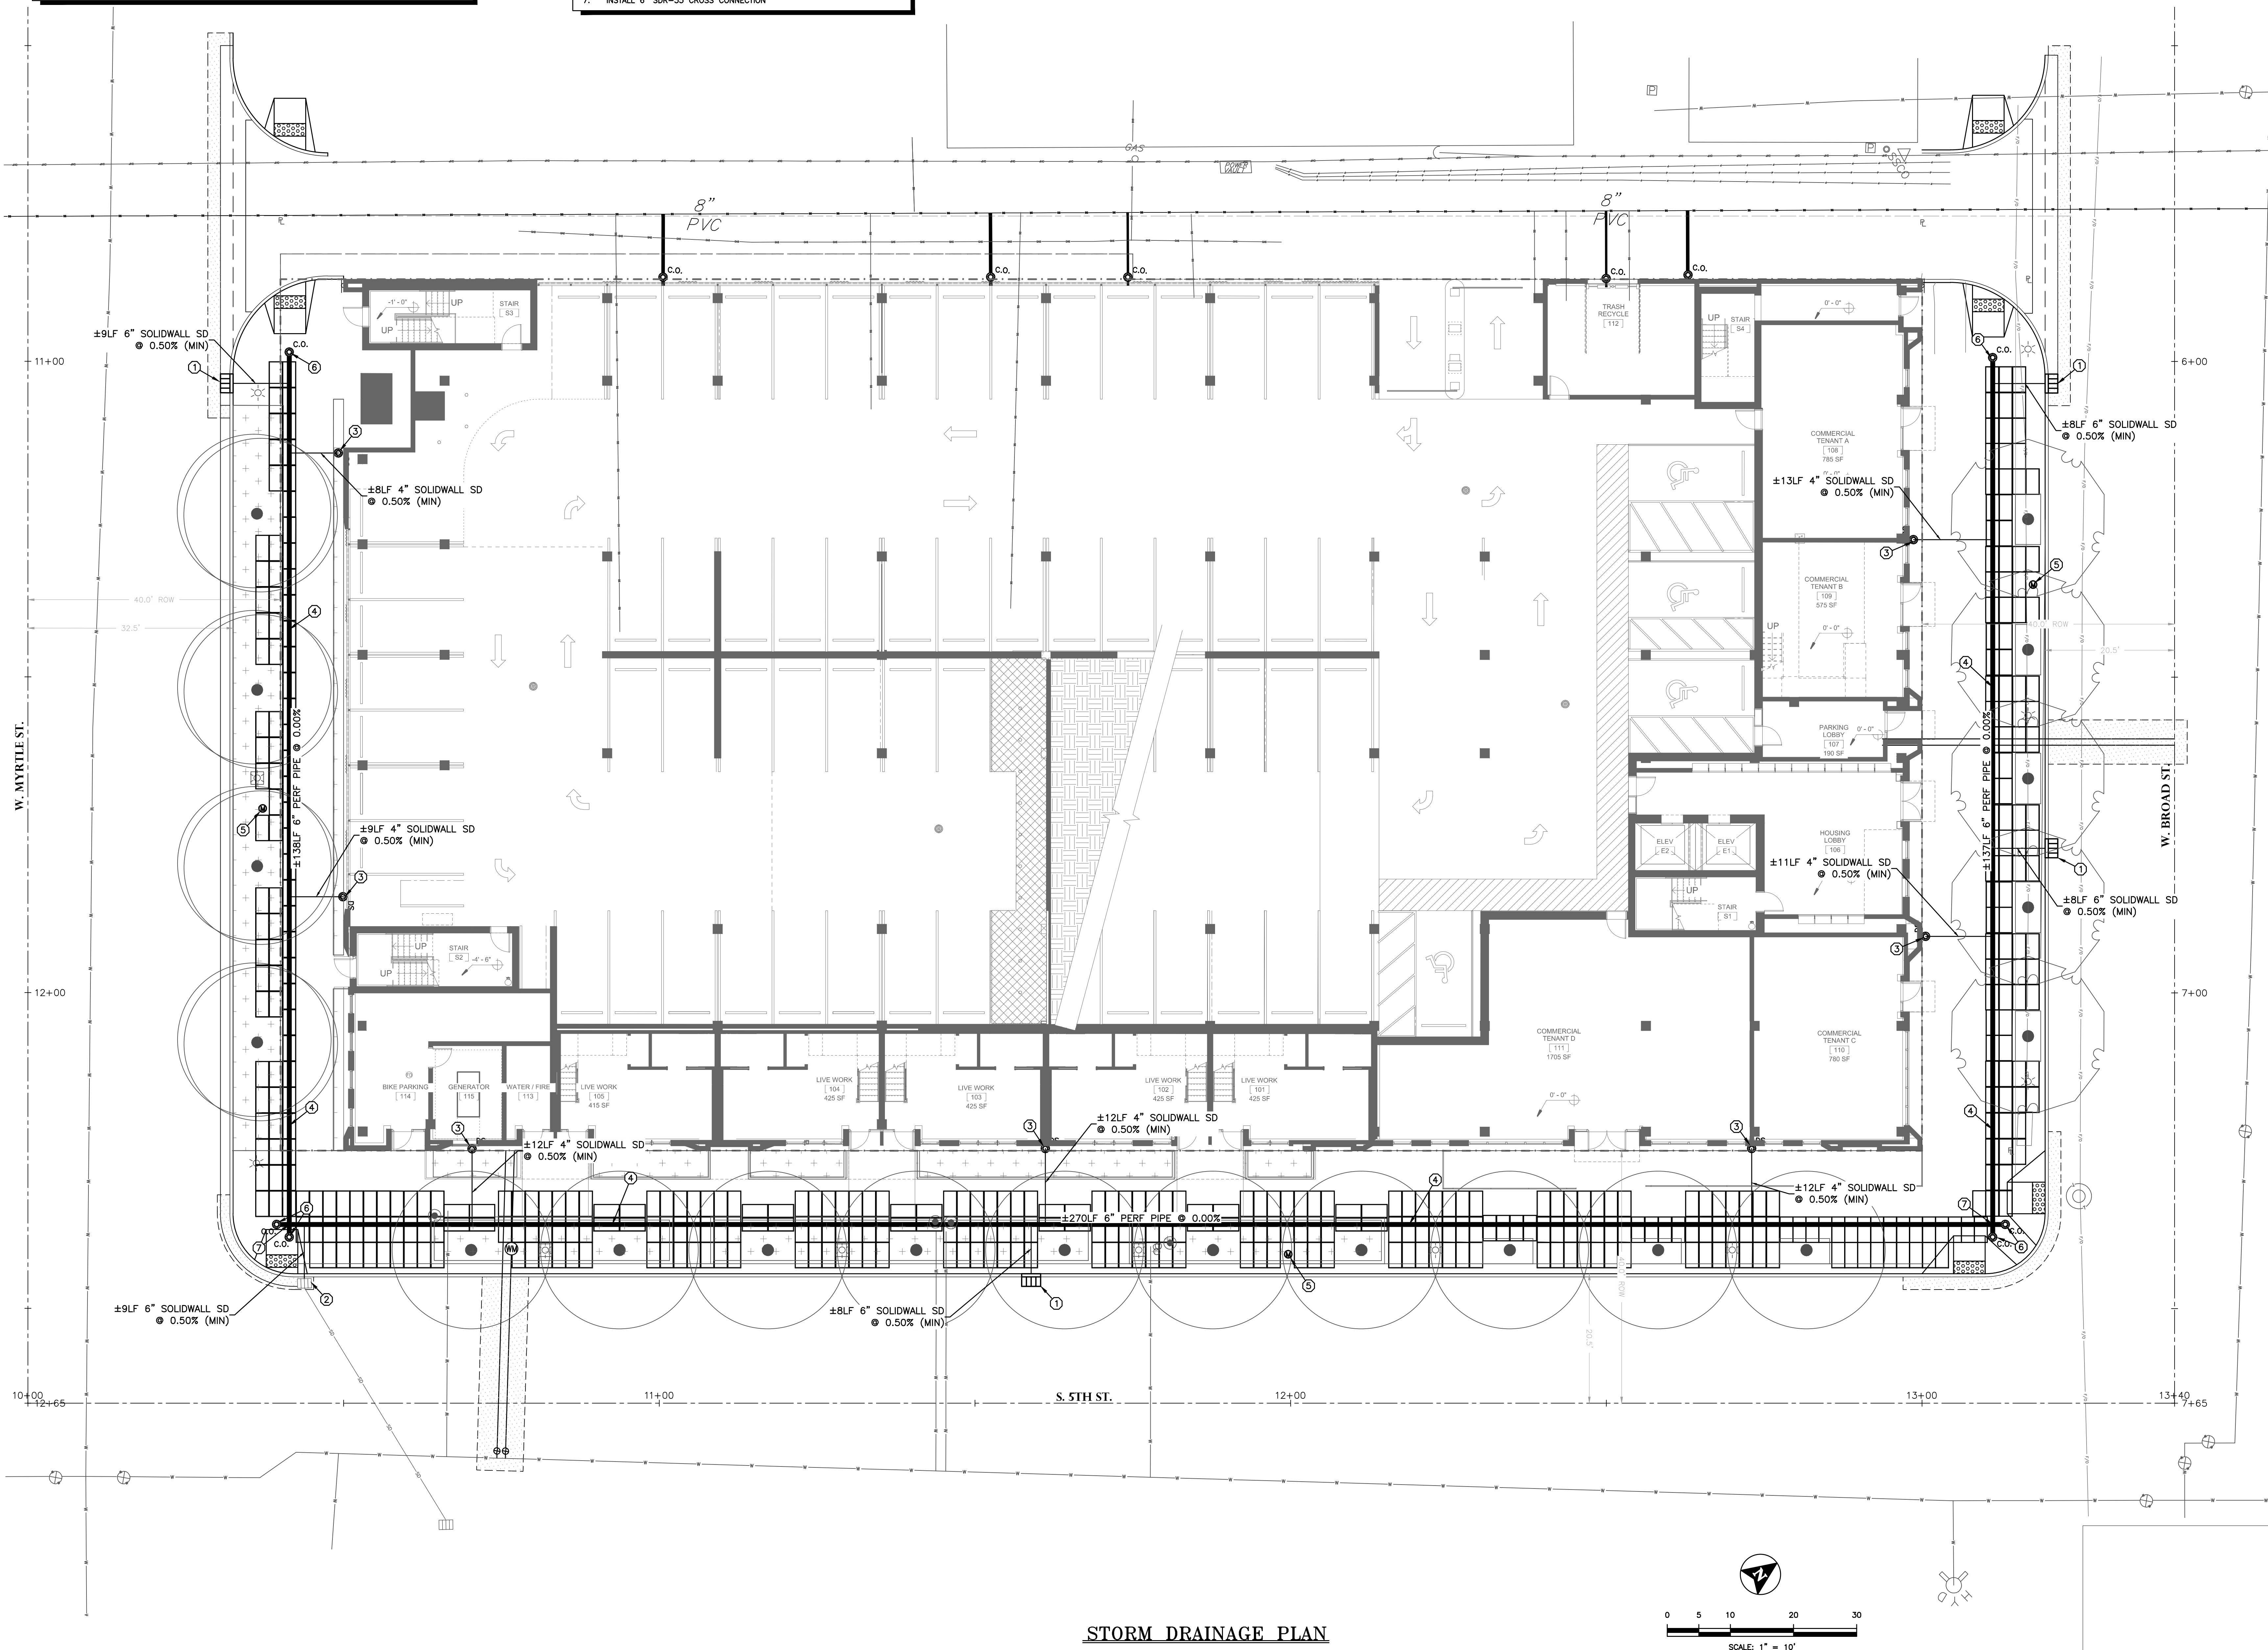

STORM DRAINAGE PLAN

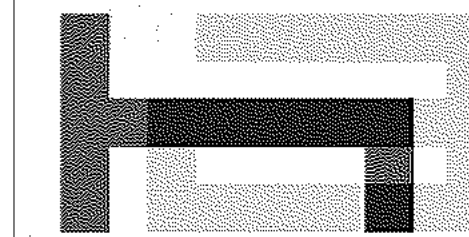

Holst Architecture

110 SE 8th Ave
Portland, OR 97214
www.holstarc.com

5TH & BROAD

401 S 5TH ST
BOISE, ID 83702

JOB NO. HA-14-111
TO: 150033



332 N. BROADMORE WAY
NAMPA, IDAHO 83687-5123

PHONE: (208) 442-6300 FAX: (208) 466-0944

PODIUM PERMIT

06.12.15

ISSUE:	DATE:
100% SD	04.14.15
PODIUM PERMIT	06.12.15
100% DD	07.09.15
50% CD	08.20.15
60% CD	09.08.15
75% CD PERMIT	09.18.15

revision list	date:
---------------	-------


sheet title:

STORM
DRAINAGE
PLAN

sheet no.:

C1.03

© 2012 HOLST ARCHITECTURE pc

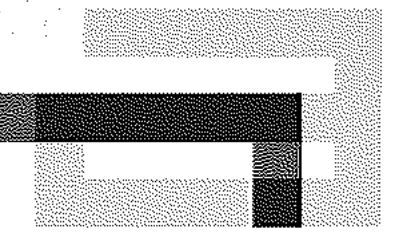

Holst Architecture

110 SE 8th Ave
Portland, OR 97214
www.holstarc.com

5TH & BROAD

401 S 5TH ST
BOISE, ID 83702

JOB NO. HA-14-111
TO: 150033



T-O ENGINEERS
332 N. BROADMORE WAY
NAMPA, IDAHO 83887-5123

PHONE: (208) 442-6300 FAX: (208) 466-0944

PODIUM PERMIT

06.12.15

ISSUE:	DATE:
100% SD	04.14.15
PODIUM PERMIT	06.12.15
100% DD	07.09.15
50% CD	08.20.15
60% CD	09.08.15
75% CD PERMIT	09.18.15

revision list	date:
WATER/FIRE RM FFE	09.15.15

sheet title:

GRADING PLAN

sheet no.:

C1.04


© 2012 HOLST ARCHITECTURE pc

NOTES


- ELEVATIONS HAVE BEEN TRUNCATED, I.E. 96.50'=2696.50'
- ALL VALVE COVERS, MANHOLE RIMS AND UPS SHALL BE SET FLUSH WITH FINISHED GRADES AND HAVE CONCRETE COLLARS WHEN PLACED IN ASPHALT OR CONCRETE AREAS.
- ALL ACCESSIBLE ROUTES TO MEET CURRENT ADA GUIDELINES. ENGINEER MAY CHECK CROSS SLOPES AND RUNNING SLOPES AFTER CONCRETE IS POURED. ANY SLOPES EXCEEDING ALLOWABLE MINIMUMS OR MAXIMUMS SHALL BE REMOVED AND REPLACED AT THE EXPENSE OF THE CONTRACTOR. CONTRACTOR SHALL VERIFY SLOPES DURING STRINGLINE/FORMING PROCESS. MAXIMUMS SHALL BE AS FOLLOWS:
CROSS SLOPE: 1.75%
RUNNING SLOPE: 4.75%
RAMP RUNNING SLOPE: 12:1
- CURB DIMENSIONS ARE TO BACK OF CURB UNLESS OTHERWISE NOTED.
- ALL PAVEMENT MARKINGS AND SIGNAGE SHALL BE PER MUTCD.
- ARCHITECTURAL AND LANDSCAPE PLANS ARE SHOWN FOR REFERENCE ONLY.
- CONTRACTOR TO REMOVE AND REPLACE ANY CURBING THAT IS DAMAGED PRIOR TO OR DURING CONSTRUCTION. REPLACEMENT CURB TO MATCH EXISTING.

KEYNOTES

- INSTALL ADA PEDESTRIAN RAMP WITH FLARES AND TRUNCATED DOMES PER ISPCW SD-712D.
- INSTALL 4" WIDE VALLEY GUTTER PER ACHD SD-708.
- INSTALL "NO PARKING" SIGN RB-3a PER MUTCD.
- REPLACE "NO PARKING" SIGN, IN KIND, PER MUTCD.

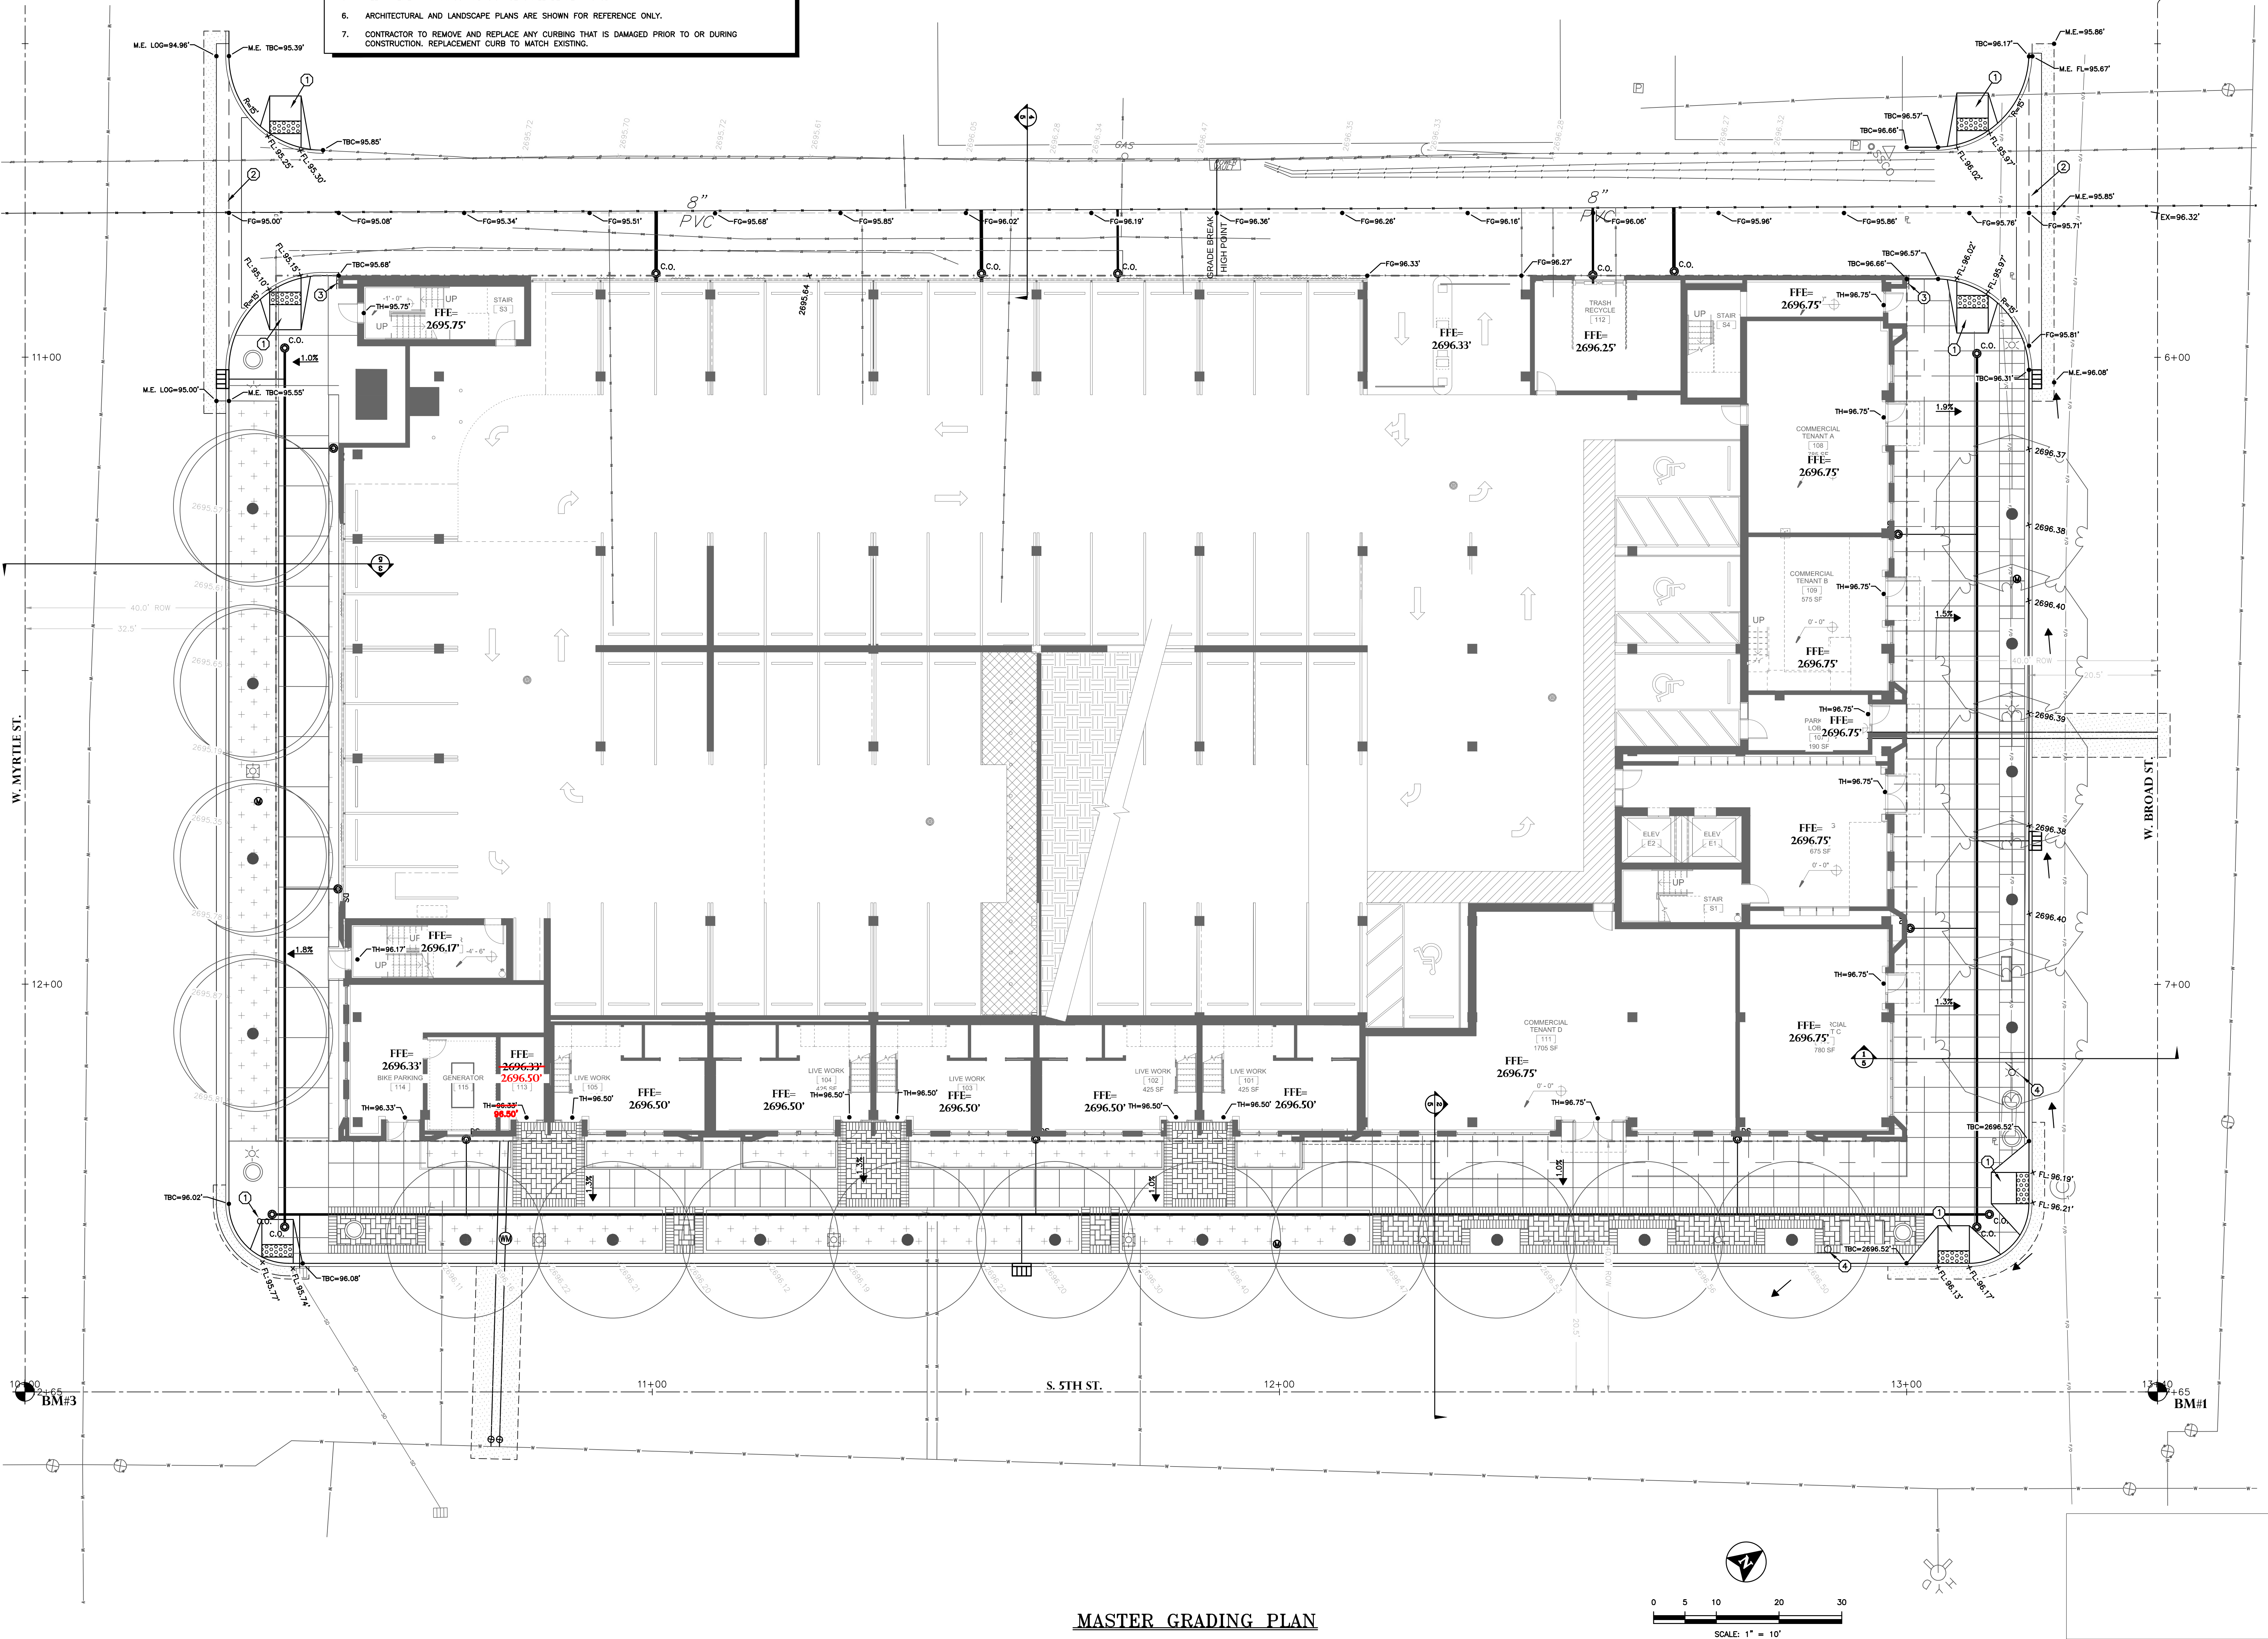

MASTER GRADING PLAN

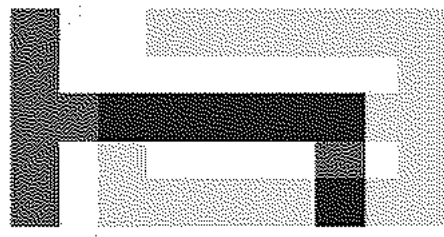

Holst Architecture

110 SE 8th Ave
Portland, OR 97214
www.holstarc.com

5TH & BROAD

401 S 5TH ST
BOISE, ID 83702

JOB NO. 14-111



STACK ROCK GROUP
STACK ROCK GROUP, INC.
LANDSCAPE
ARCHITECTURE / MASTER
PLANNING

WILLET C. HOWARD, P.L.A.
OFFICE: (208) 345-0500
EMAIL: WIL@STACKROCKGROUP.COM
WWW.STACKROCKGROUP.COM

THE GRAPHICS AND DESIGNS
ON THIS SHEET ARE
DELIVERABLES THAT REMAIN
AT ALL TIMES PROPERTY OF
STACK ROCK GROUP, INC.

REPRODUCTION OR REUSE OF
THIS PRODUCT CONTAINED
HEREIN IS PROHIBITED WITHOUT
THE WRITTEN CONSENT OF
STACK ROCK GROUP, INC.


©2015 STACK
ROCK GROUP, INC.



CONSTRUCTION
DOCUMENTS

ISSUE:	DATE:
100% SD	04.14.15
PODIUM PERMIT	06.12.15
100% DD	07.09.15
50% CD	08.20.15
60% CD	09.08.15
75% CD PERMIT	09.18.15

revision list	DATE:
---------------	-------

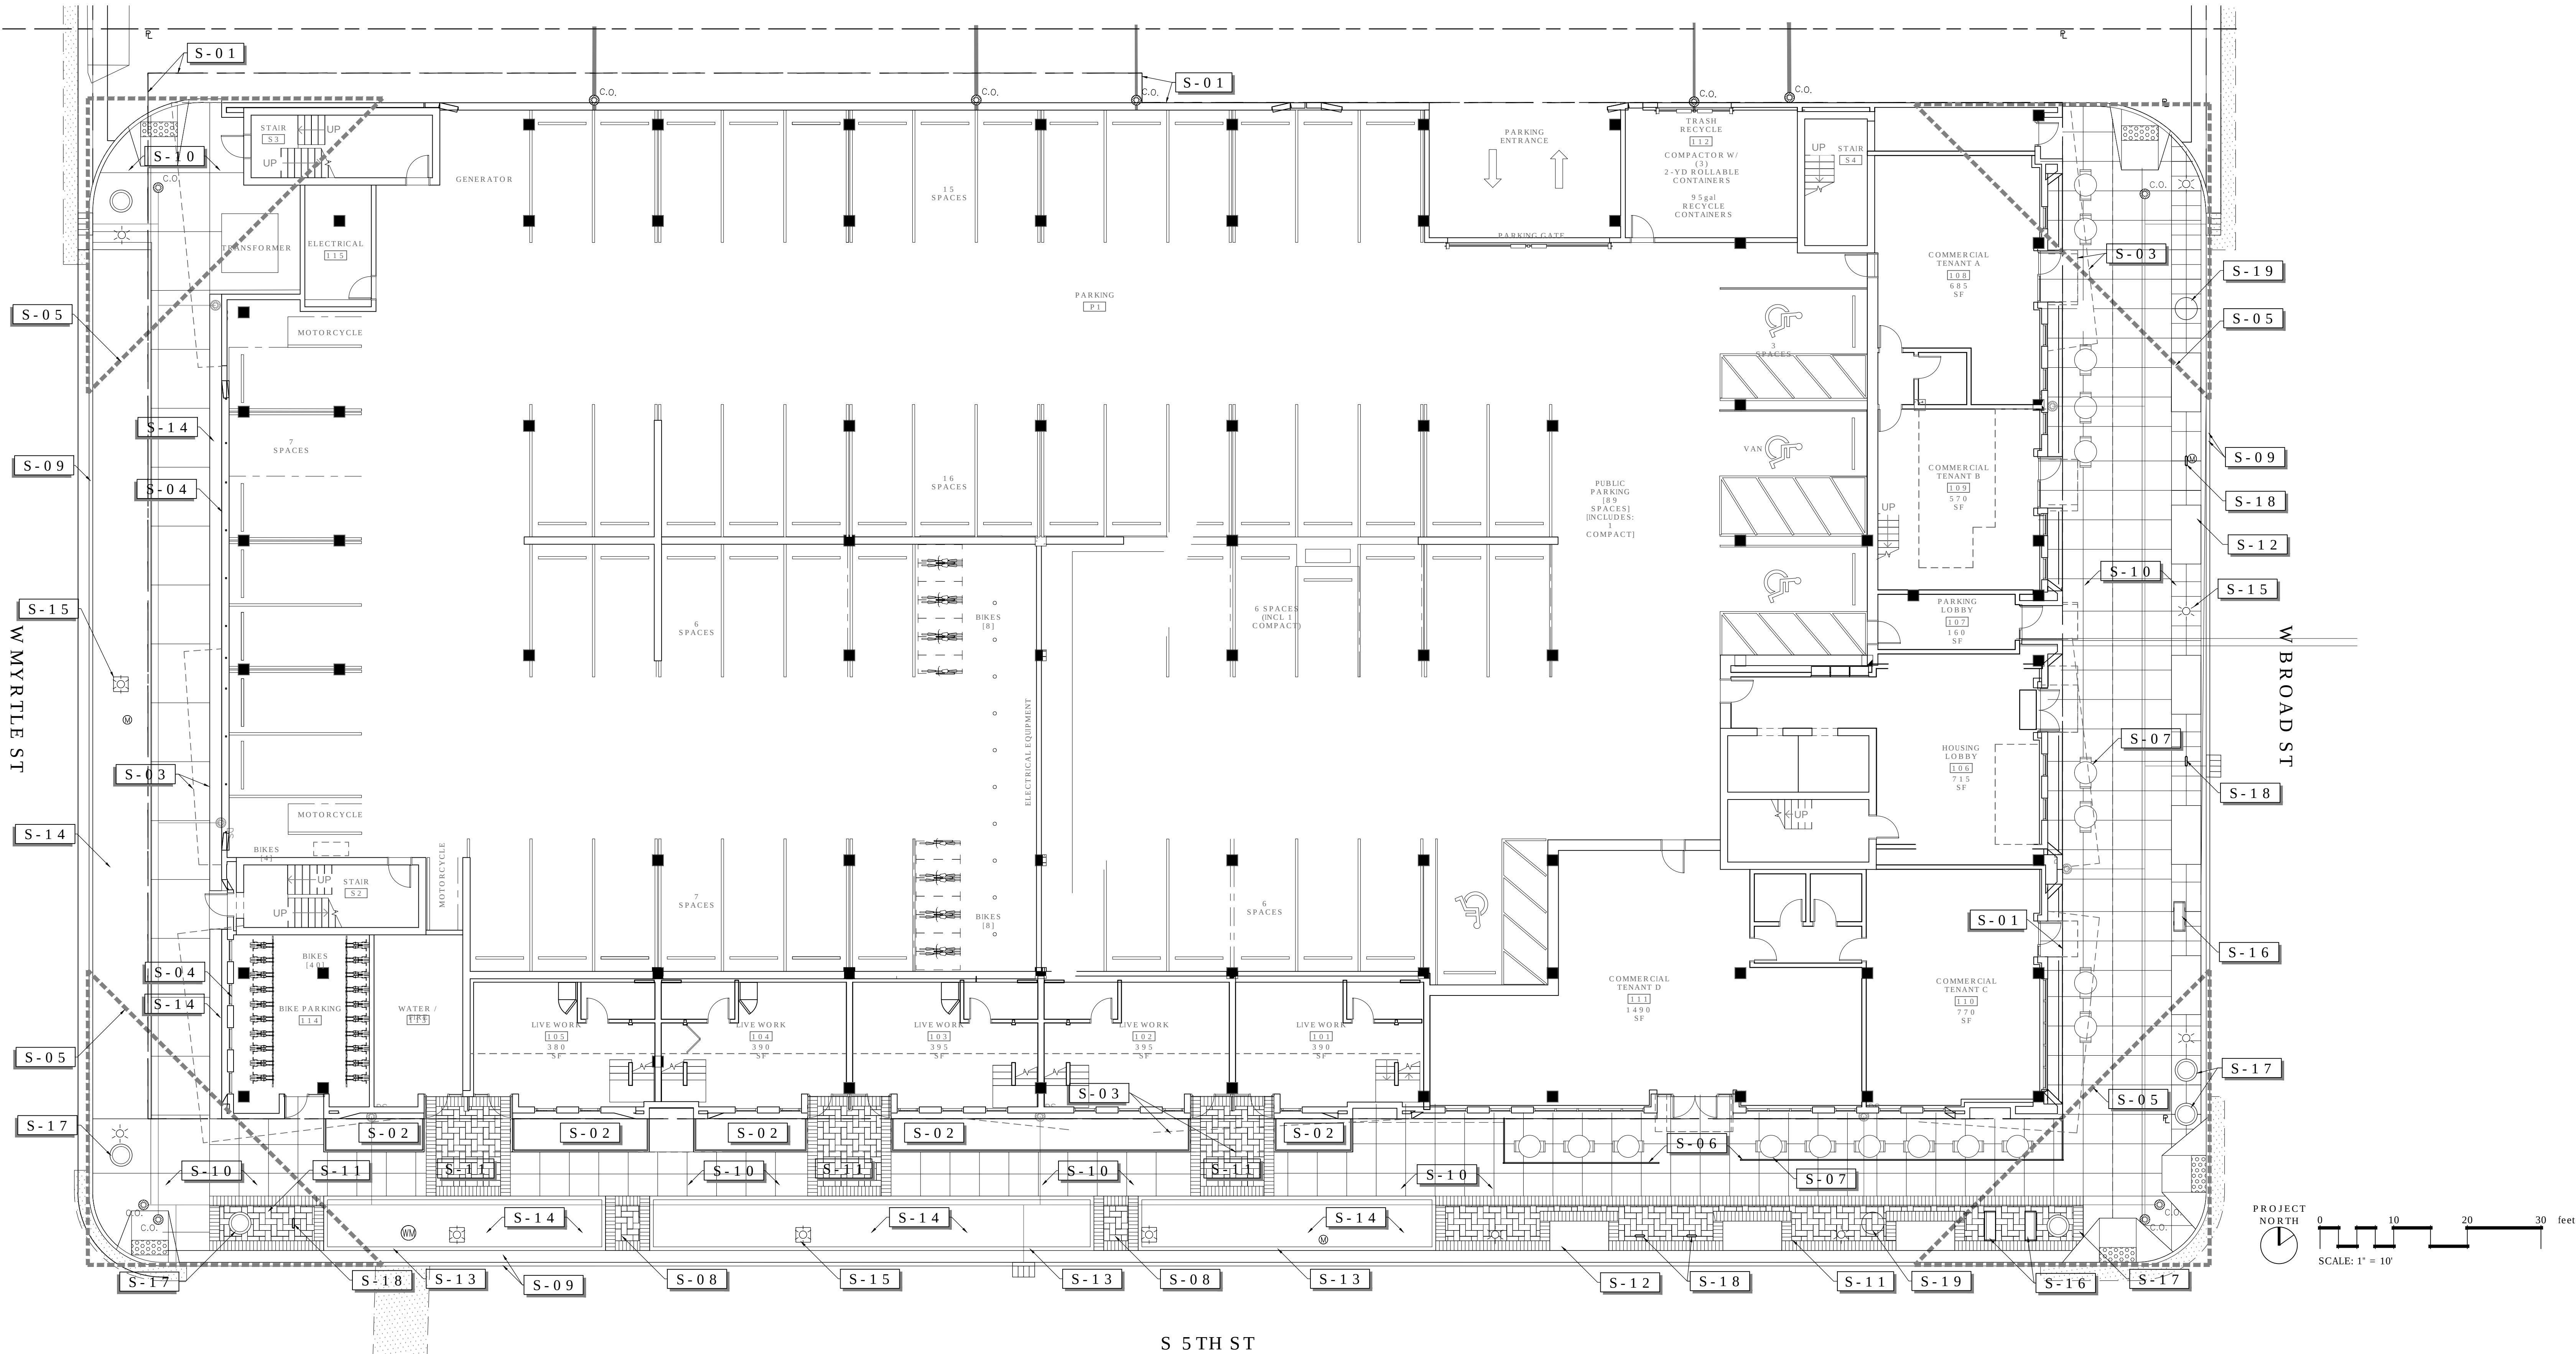

LANDSCAPE ELEMENTS SPECIFICATIONS & REQUIREMENTS:

ALL ELEMENTS OR APPROVED EQUALS TO BE APPROVED BY CCDC

PAVERS:

IRONSPOT MANGANESE IN HERRINGBONE PATTERN BY ENDICOTT CLAY PRODUCTS FROM THE MASONRY CENTER (2-1/4"x4"x8")

PAVERS TO HAVE 1/2" LUG

TREE GRATES:

4'x8' RECTANGULAR CAST IRON 'KIVA' MODEL BY URBAN ACCESSORIES

HISTORIC STREET LIGHT:

HISTORIC BOISE CAST ALUMINUM LIGHT POLE WITH DUPLEX OUTLET, 110V CIRCUIT FOR DUPLEX OUTLET LOCATED AT THE TOP OF LUMINAIRE EQUIP WITH FIXED TOP BRACKET, BOLT-ON BANNER ARM, AND LOWER EYELET. BANNER ARM SHALL BE LOCATED 4" BELOW TOP OF POLE AND EYELET PLACED 51" BELOW THE ARM, GENERALLY PERPENDICULAR TO AND FACING THE SIDEWALK. ALL METAL TO BE POWDER COAT RAL 6009

LITTER RECEPTACLE:

CHASE PARK MODEL BY LANDSCAPE FORMS, POWDER COAT GREEN RAL 6009

BIKE RACK: SINGLE BEND BY KB FABRICATION, POWDER COAT GREEN RAL 6009

BENCH:

4' CAST IRON POWDER COAT GREEN RAL 6009 WITH WOOD OR RECYCLED SLATS COLOR - WALNUT, MODEL C-10 BY VICTOR STANLEY, INC.

SURFACE MOUNT WITH 1/2" EXPANSION BOLT

MOVEABLE PLANTERS: 3'w x 1'7"h CAST STONE BY IDAHO PRECAST CONCRETE

ALL EXPOSED METAL TO BE POWDER COAT FINISHED WITH RAL 6009, DARK GREEN OR APPROVED EQUAL

ALL WOOD MUST BE SMOOTH FINISHED AND TREATED WITH CCDC STANDARD MINWAX RED MAHOGONY STAIN AND PENETRATING SEALER

ALL EXPOSED BOLT NUTS MUST BE VANDAL-PROOF TO PREVENT UNWANTED REMOVAL

**REVIEW CITY OF BOISE & CCDC SPECS PRIOR TO INSTALLATION

LANDSCAPE & SITE ELEMENTS:

	STREETSCAPE PAVER SOLDIER COURSE		STORM DRAIN
	STREETSCAPE PAVERS		CLEAN OUT
	HISTORIC STREET LIGHT		STORM STRUCTURE
	SINGLE BEND BICYCLE RACK		WATER STRUCTURE
	4' x 8' CAST IRON TREE GRATE		STREAM PIPE APP
	SEAT BENCH		
	MOVABLE CONCRETE PLANTER		
	TABLE TOP SEATING		
	TRASH RECEPTACLE		
	CLEAR VISION TRIANGLE: 40' x 40' NO TREES OR SHRUBS OVER 36" PLANTED WITHIN		

LANDSCAPE SITE PLAN SCHEDULE

CODE	DESCRIPTION	DETAIL
S-01	PROPERTY LINE	
S-02	RAISED PLANTER WALL (SEE ARCHITECTURAL)	
S-03	BUILDING OVERHANG OR CANOPY ABOVE, TYP (SEE ARCHITECTURAL PLANS)	
S-04	GREENWALL (SEE ARCHITECTURAL)	
S-05	40' x 40' CLEAR VISION TRIANGLE, NO TREES OR SHRUBS OVER 36" PLANTED WITHIN	
S-06	OUTDOOR DINING AREA BARRIER (SEE ARCHITECTURAL)	
S-07	TABLE TOP, TYP (REFER TO ARCHITECTURAL)	
S-08	ACCESS ACROSS LANDSCAPE SWALE, PAVERS (REFER TO HARDSCAPE PLAN)	
S-09	6" CONCRETE CURB ABUTTING CONCRETE IN CURB ZONE, 18" ON S 5TH ST & 8" W BROAD ST, NO CURB ZONE ON W MYRTLE ST (SEE L1.01 & REFER TO CIVIL)	
S-10	SITE CONCRETE (REFER TO L1.01 FOR CCDC ZONE DESIGNATION AND HARDSCAPE PLAN FOR SCORELINES)	
S-11	PAVERS (REFER TO HARDSCAPE PLAN)	
S-12	4' x 8' TREE GRATE, TYP, CAST IRON 'KIVA' MODEL, (5) ON W BROAD ST & (3) ON S 5TH STREET	
S-13	CONCRETE CURB AROUND LANDSCAPE SWALE EXTRUDED 6" ABOVE WALKABLE SURFACE	
S-14	GROUND LEVEL PLANTER AREA	
S-15	HISTORIC STREET LIGHT, TYP, (3) ON W MYRTLE, (5) ON S 5TH ST, (3) ON W BROAD ST, REFER TO ELECTRICAL ENGINEERS PLANS	
S-16	SEAT BENCH, CAST IRON FRAME WITH WOODEN SLATS	
S-17	MOVABLE CONCRETE PLANTER	
S-18	SINGLE BEND BICYCLE RACK	
S-19	TRASH RECEPTACLE, CHASE PARK BY LANDSCAPE FORMS	/



110 SE 8th
Portland, OR 97214
www.holstarc.com

5TH & BROADWAY

401 S 5TH
BOISE, ID 83

JOB NO. 14




STACK ROCK GROUP, INC.
L A N D S C A P E
ARCHITECTURE / MASTER
P L A N N I N G

WILLET C HOWARD, P.L.
OFFICE: (208) 345.0500
EMAIL: WILL@STACKROCKGROUP.COM
WWW.STACKROCKGROUP.COM

THE GRAPHICS AND DESIGN:
ON THIS SHEET ARE
DELIVERABLES THAT REMAIN
AT ALL TIMES PROPERTY OF
STACK ROCK GROUP, INC.

REPRODUCTION OR REUSE OF
THIS PRODUCT CONTAINED
HEREIN IS PROHIBITED WITHOUT
THE WRITTEN CONSENT OF
STACK ROCK GROUP, INC.

© 2015 STACK
ROCK GROUP INC

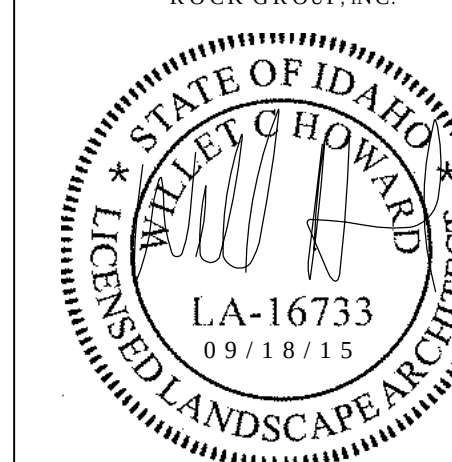

CONSTRUCTION
DOCUMENT

issue:	d
100% SD	04.14
PODIUM PERMIT	06.12
100% DD	07.09
50% CD	08.20
60% CD	09.08
75% CD PERMIT	09.18




sheet

SITE INVENTORY
TREE SURVEY

sheet

L1.10

© 2012 HOLST ARCHITECTURE

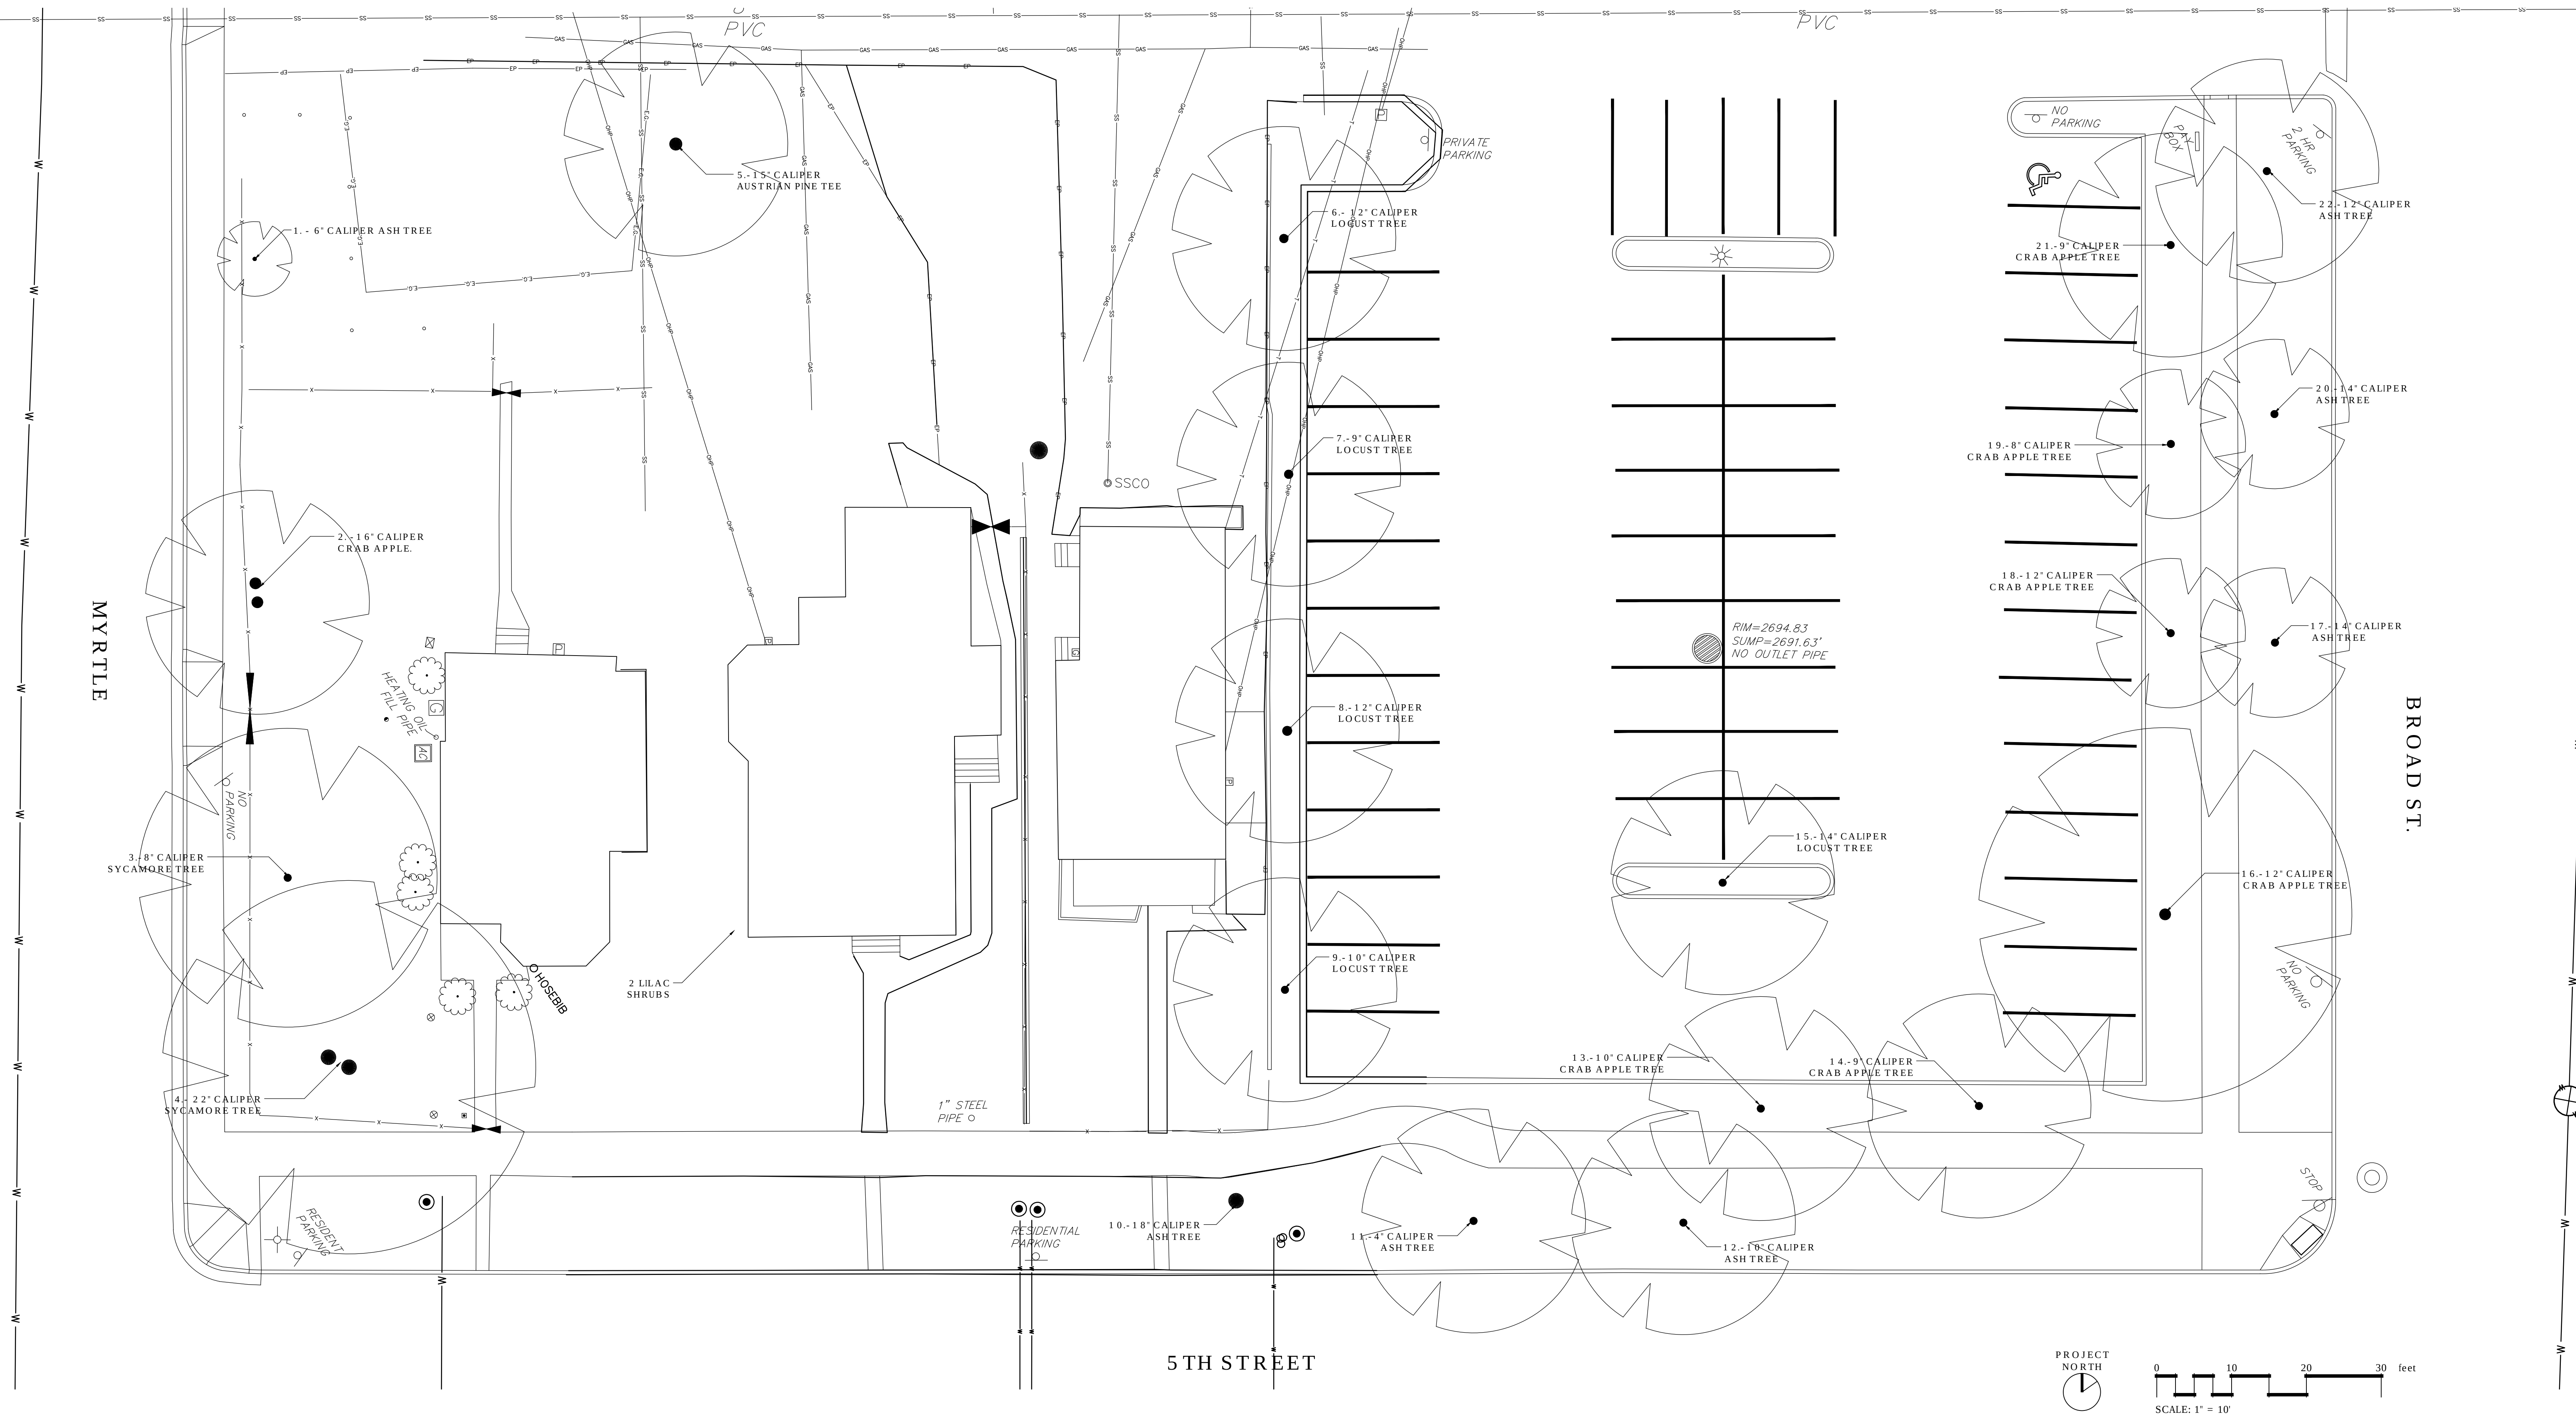


TREES TO BE REMOVED:

- | | | |
|-----|----------------------------|-------------|
| 1. | ASH TREE, | 6" CALIPER |
| 2. | FLOWERING CRAB APPLE TREE, | 16" CALIPER |
| 3. | SYCAMORE TREE, | 8" CALIPER |
| 4. | SYCAMORE TREE, | 22" CALIPER |
| 5. | AUSTRIAN PINE TREE, | 15" CALIPER |
| 6. | LOCUST TREE, | 12" CALIPER |
| 7. | LOCUST TREE, | 9" CALIPER |
| 8. | LOCUST TREE, | 12" CALIPER |
| 9. | LOCUST TREE, | 10" CALIPER |
| 10. | ASH TREE, | 18" CALIPER |
| 11. | ASH TREE, | 4" CALIPER |
| 12. | ASH TREE, | 10" CALIPER |
| 13. | FLOWERING CRAB APPLE TREE, | 10" CALIPER |
| 14. | FLOWERING CRAB APPLE TREE, | 9" CALIPER |
| 15. | LOCUST TREE, | 14" CALIPER |
| 16. | FLOWERING CRAB APPLE TREE, | 12" CALIPER |
| 17. | ASH TREE, | 14" CALIPER |
| 18. | FLOWERING CRAB APPLE TREE, | 12" CALIPER |
| 19. | FLOWERING CRAB APPLE TREE, | 8" CALIPER |
| 20. | ASH TREE, | 14" CALIPER |
| 21. | FLOWERING CRAB APPLE TREE, | 9" CALIPER |
| 22. | ASH TREE, | 12" CALIPER |

TOTAL TREES TO BE REMOVED:
TOTAL TREE CALIPERS:

22
247*

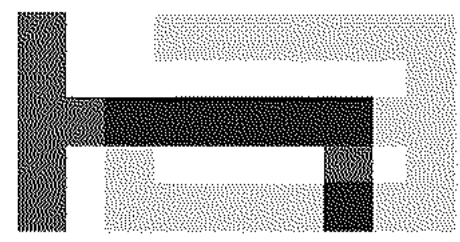

Holst Architecture

110 SE 8th Ave
Portland, OR 97214
www.holstarc.com

5TH & BROAD

401 S 5TH ST
BOISE, ID 83702

JOB NO. 14-111

CONSTRUCTION DOCUMENTS

ISSUE:	DATE:
100% SD	04.14.15
PODIUM PERMIT	06.12.15
100% DD	07.09.15
50% CD	08.20.15
60% CD	09.08.15
75% CD PERMIT	09.18.15

revision list

date:


sheet title:

ARCHITECTURAL SITE PLAN

sheet no.:

A1.00

© 2012 HOLST ARCHITECTURE pc

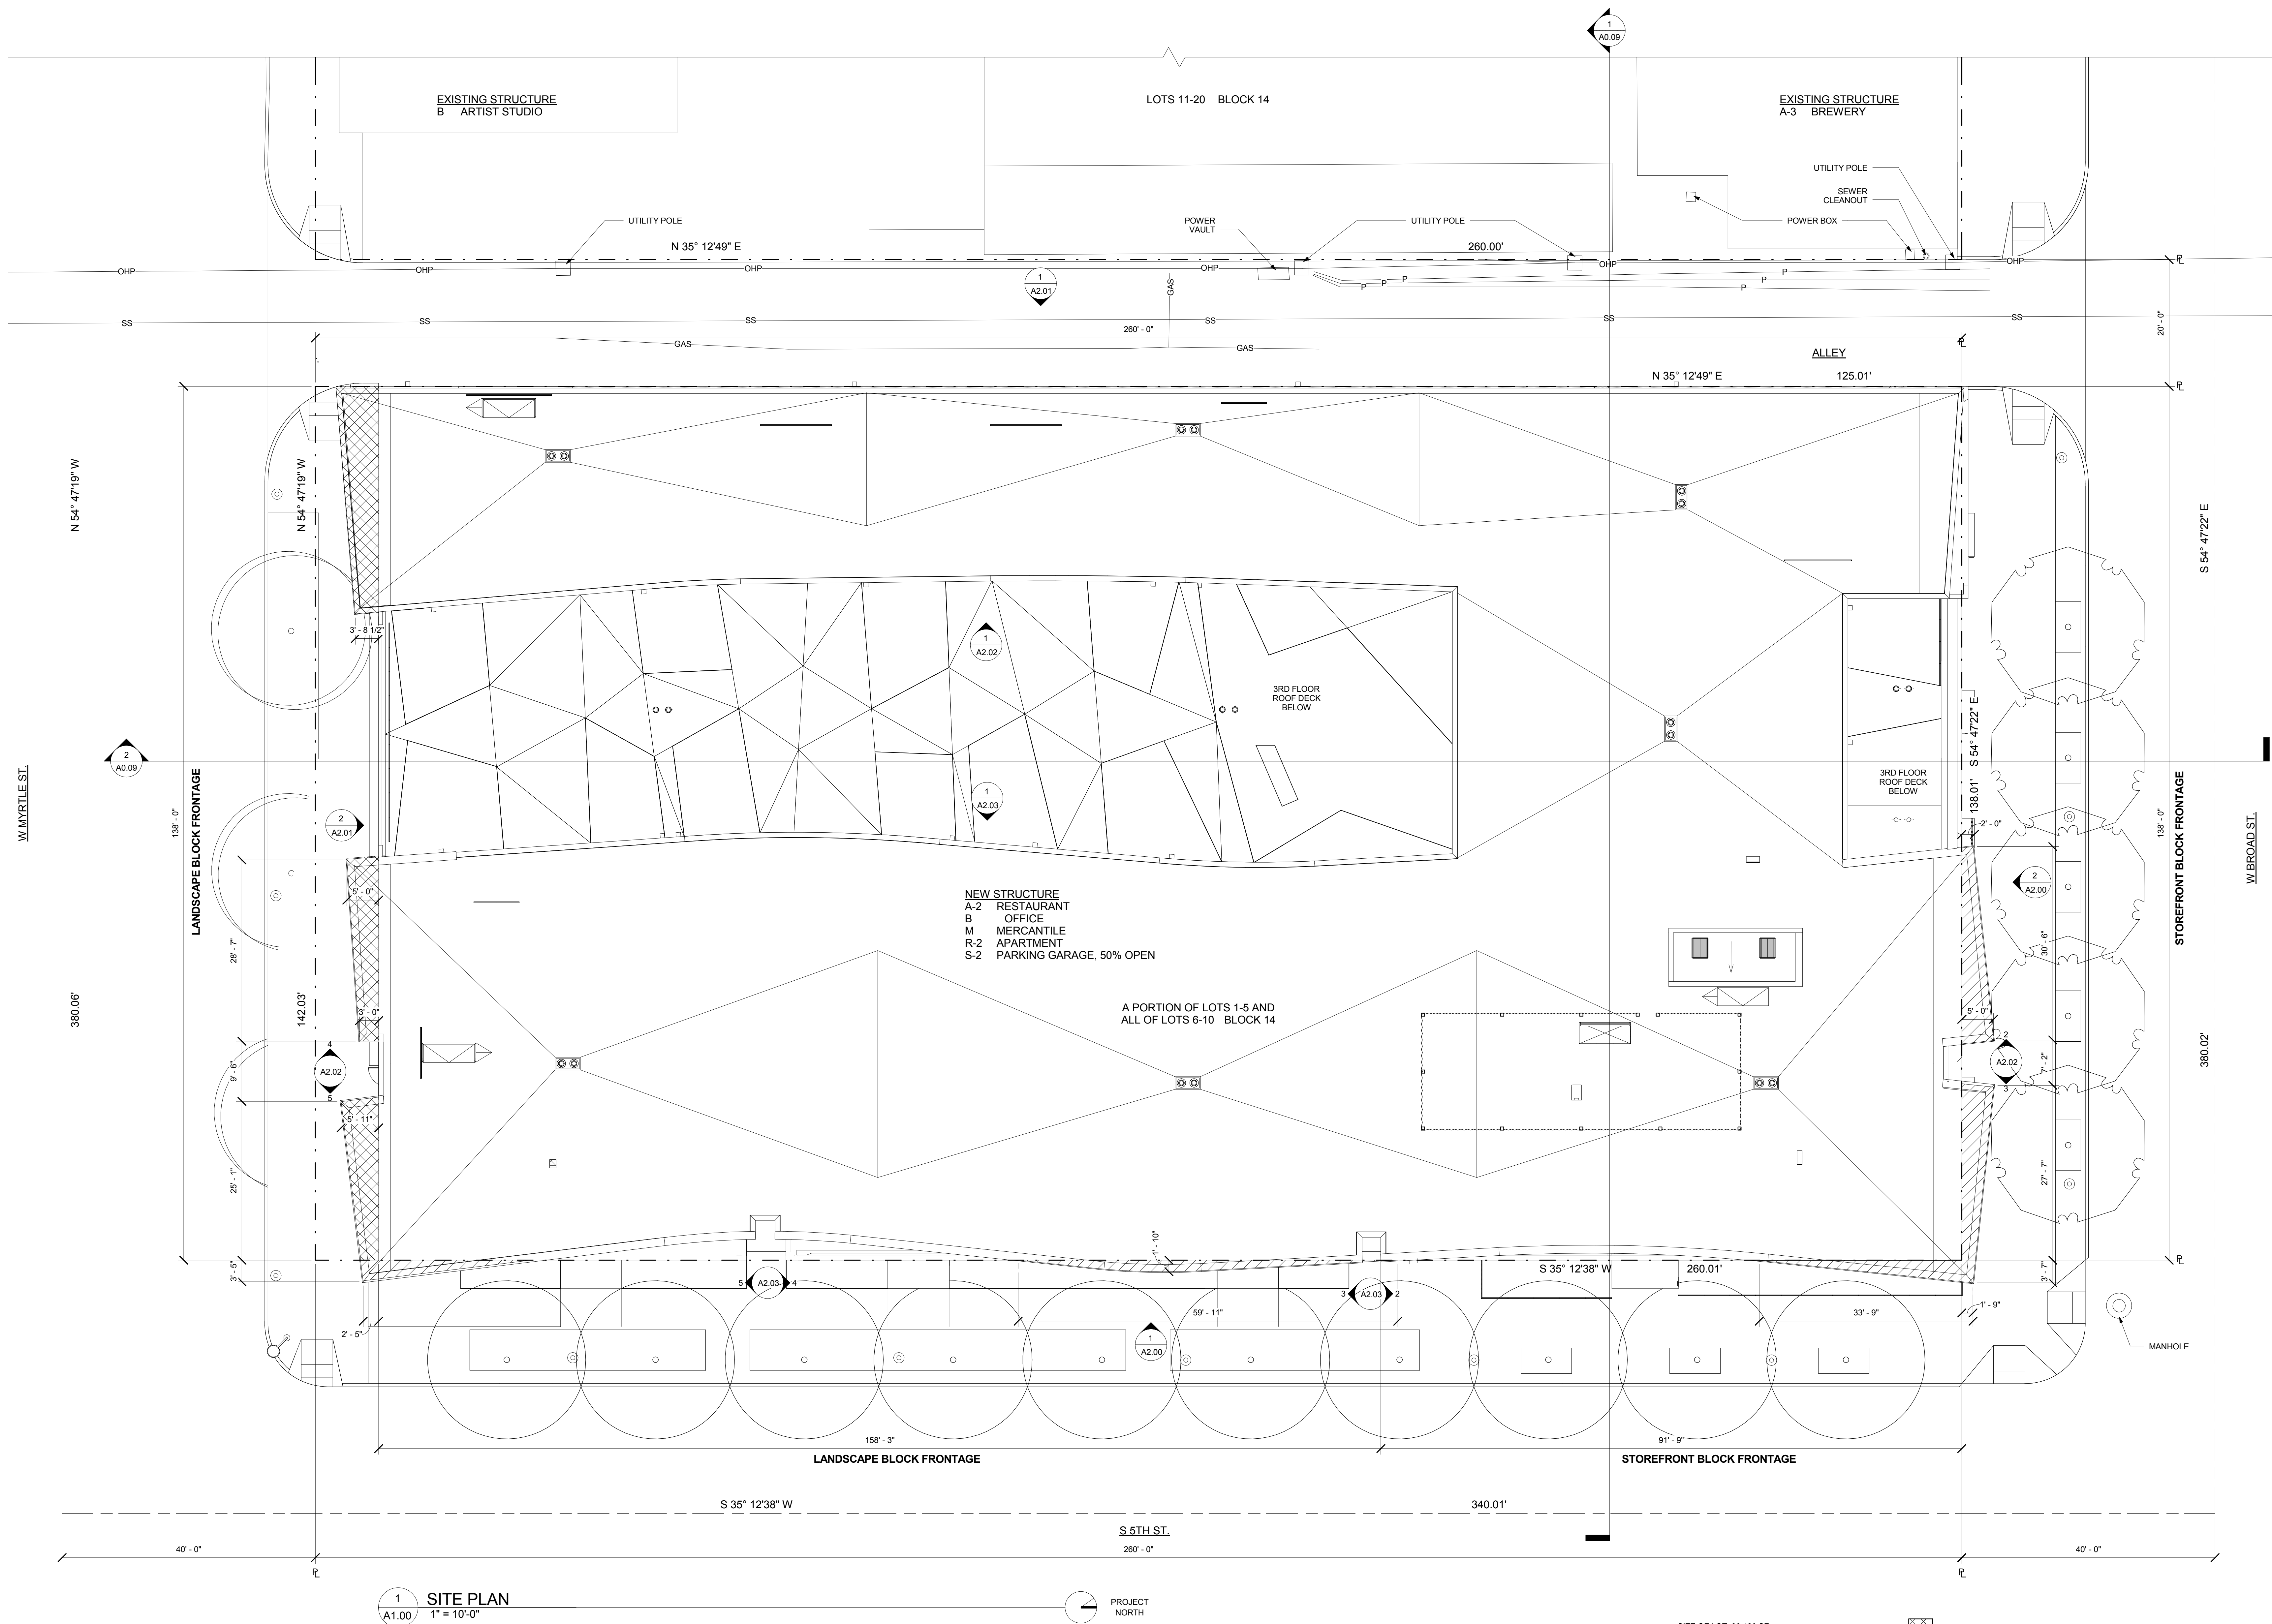


SIZE OF LOT: 36,426 SF

LEGAL DESCRIPTION:

A PORTION OF LOTS 1 THROUGH 5 AND ALL OF LOTS 6 THROUGH 10, BLOCK 14 OF THE PLAT OF BLOCKS 7 TO 15, INCLUSIVE, DAVIS ADDITION LOCATED IN THE SE 1/4 OF SECTION 10, TOWNSHIP 3 NORTH, RANGE 2 EAST, BOISE MERIDIAN, CITY OF BOISE, ADA COUNTY, IDAHO

PROJECTION OVER SETBACK
PROJECTION OVER PROPERTY LINE

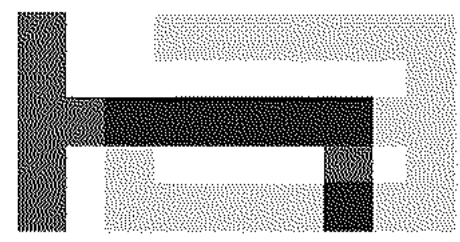

Holst Architecture

110 SE 8th Ave
Portland, OR 97214
www.holstarc.com

5TH & BROAD

401 S 5TH ST
BOISE, ID 83702

JOB NO. 14-111

CONSTRUCTION DOCUMENTS

Issue:	date:
100% SD	04.14.15
PODIUM PERMIT	06.12.15
100% DD	07.09.15
50% CD	08.20.15
60% CD	09.08.15
75% CD PERMIT	09.18.15

revision list date:


sheet title:

LEVEL 01 FLOOR PLAN

sheet no.:


A1.01

© 2012 HOLST ARCHITECTURE pc

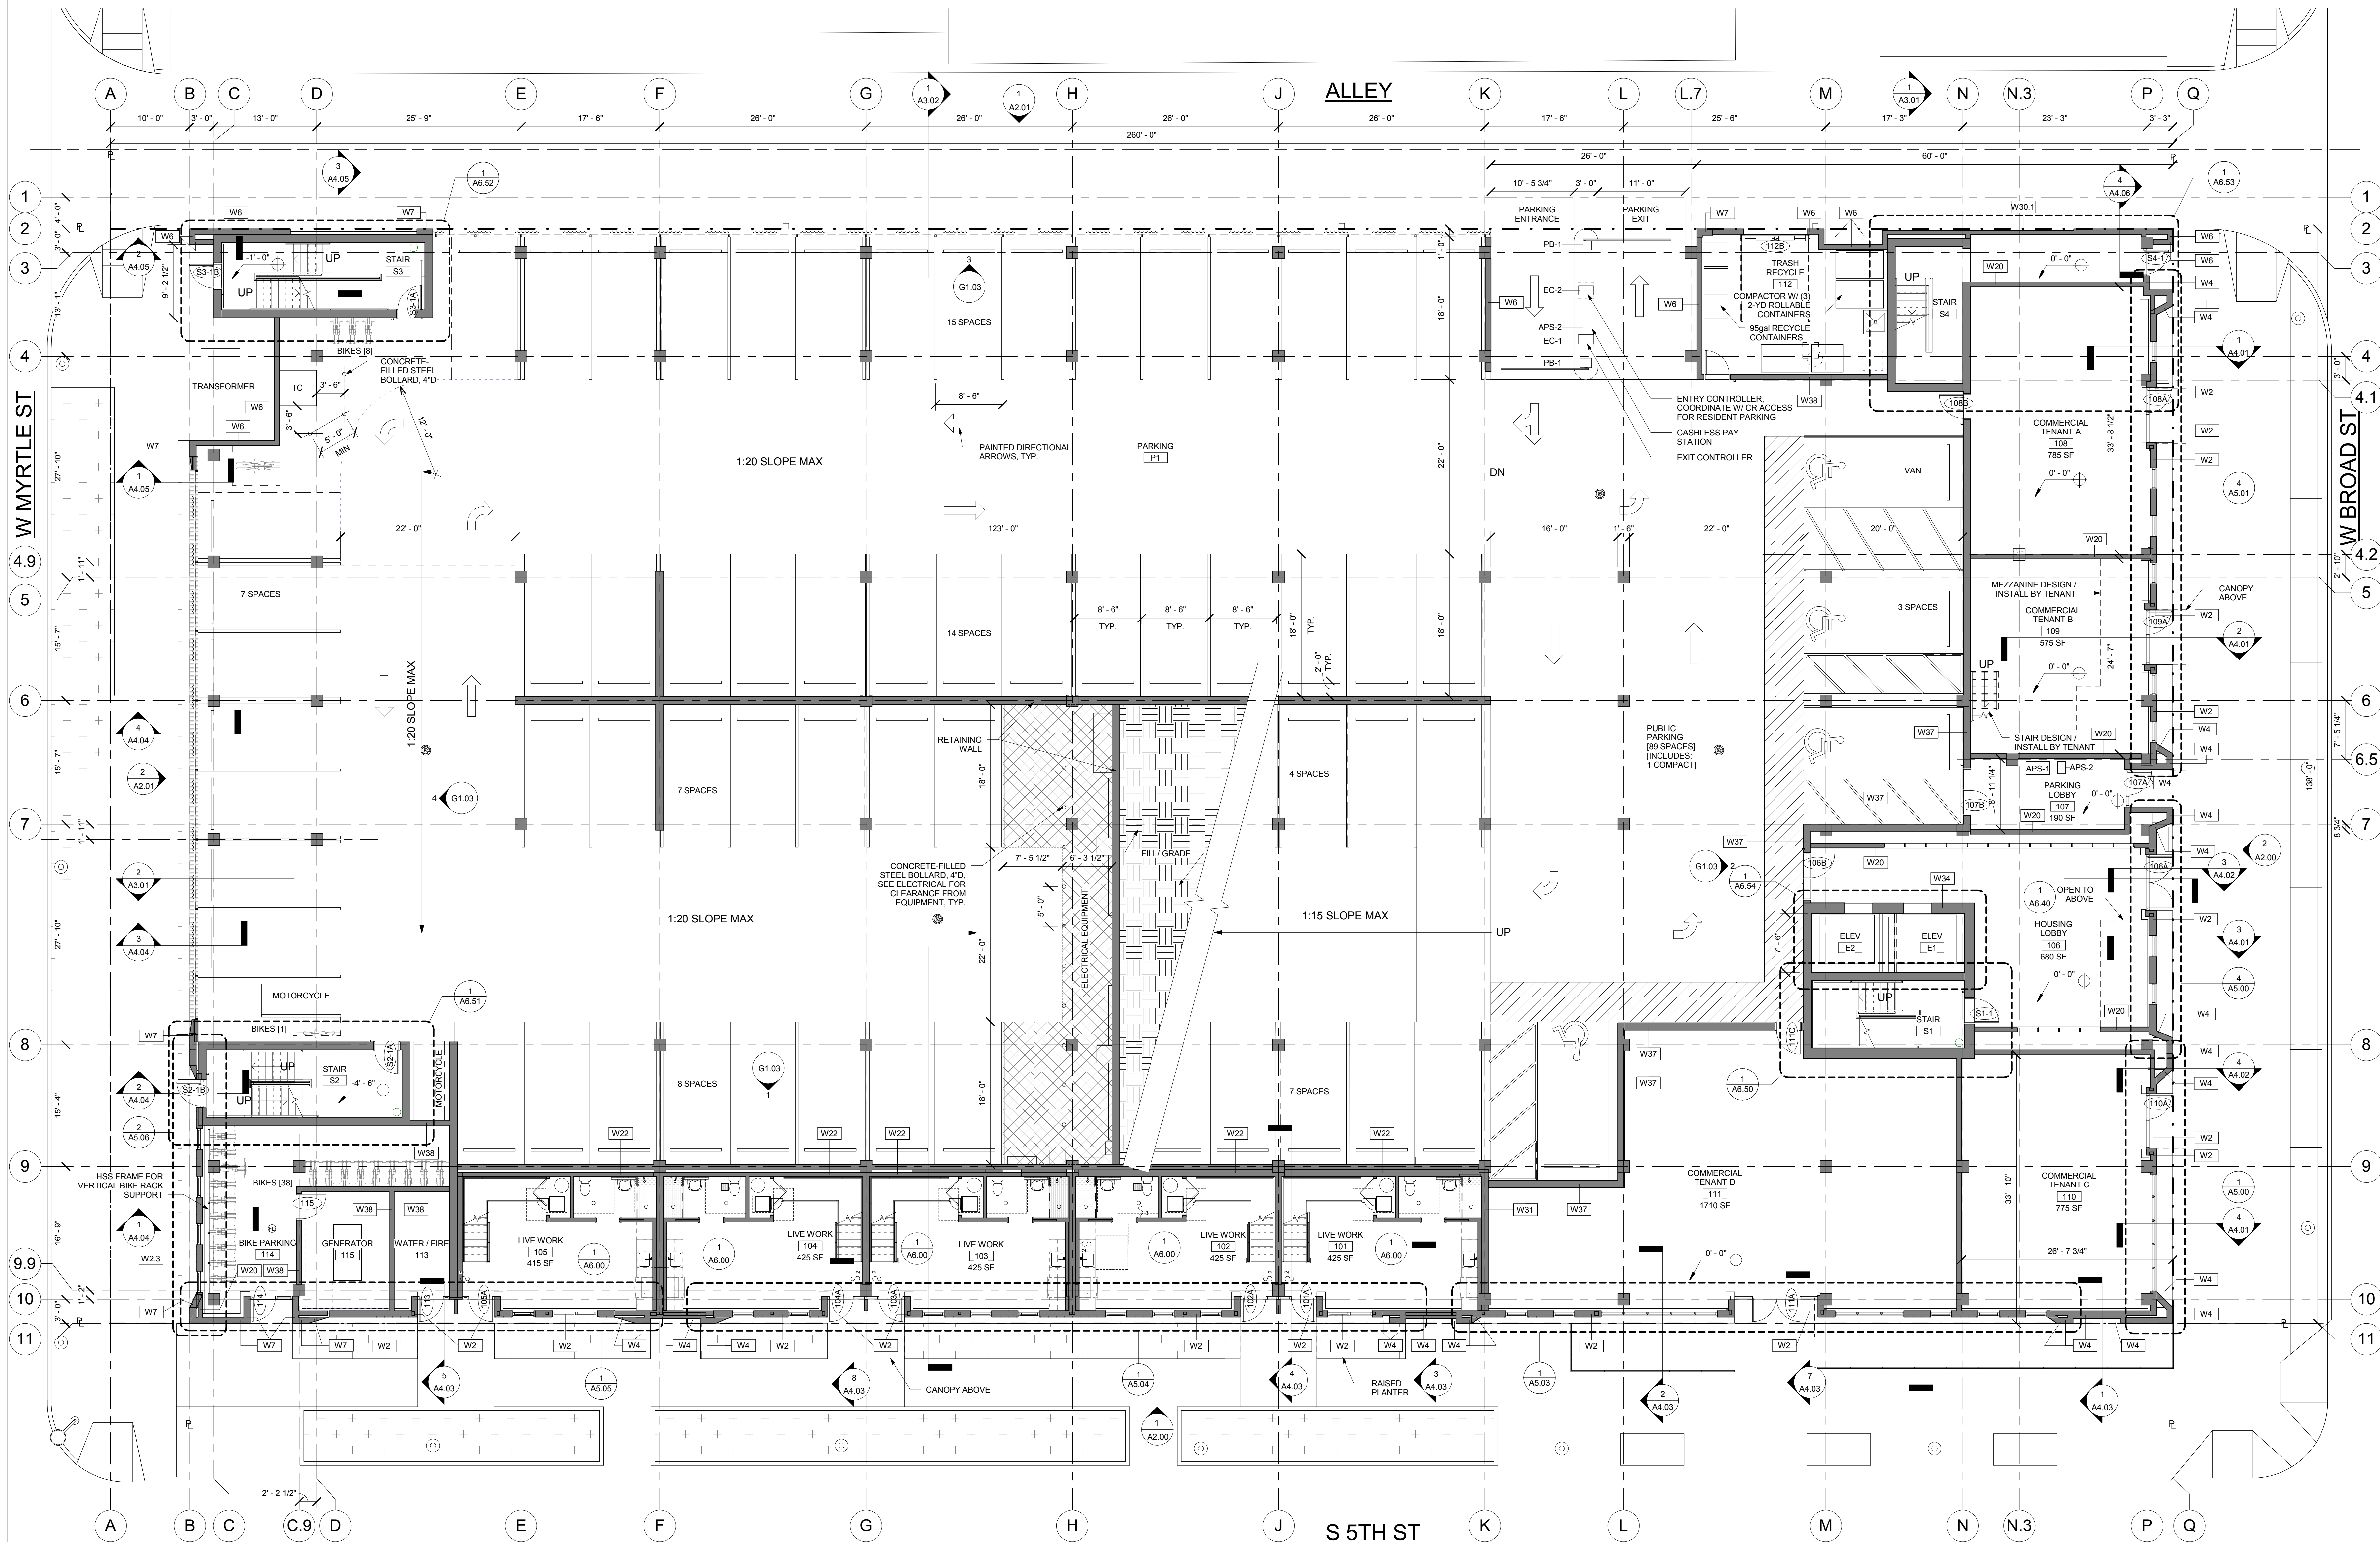

1 LEVEL 01 FLOOR PLAN
A1.01 1/8" = 1'-0"

PROJECT NORTH

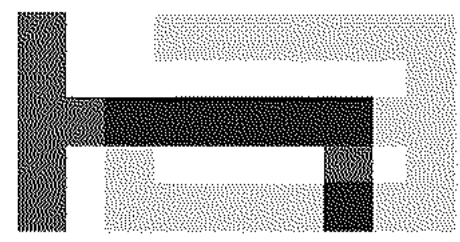

Holist Architecture

110 SE 8th Ave
Portland, OR 97214
www.holistarc.com

5TH & BROAD


401 S 5TH ST
BOISE, ID 83702

JOB NO. 14-111

CONSTRUCTION DOCUMENTS

ISSUE:	DATE:
100% SD	04.14.15
PODIUM PERMIT	06.12.15
100% DD	07.09.15
50% CD	08.20.15
60% CD	09.08.15
75% CD PERMIT	09.18.15

revision list date:

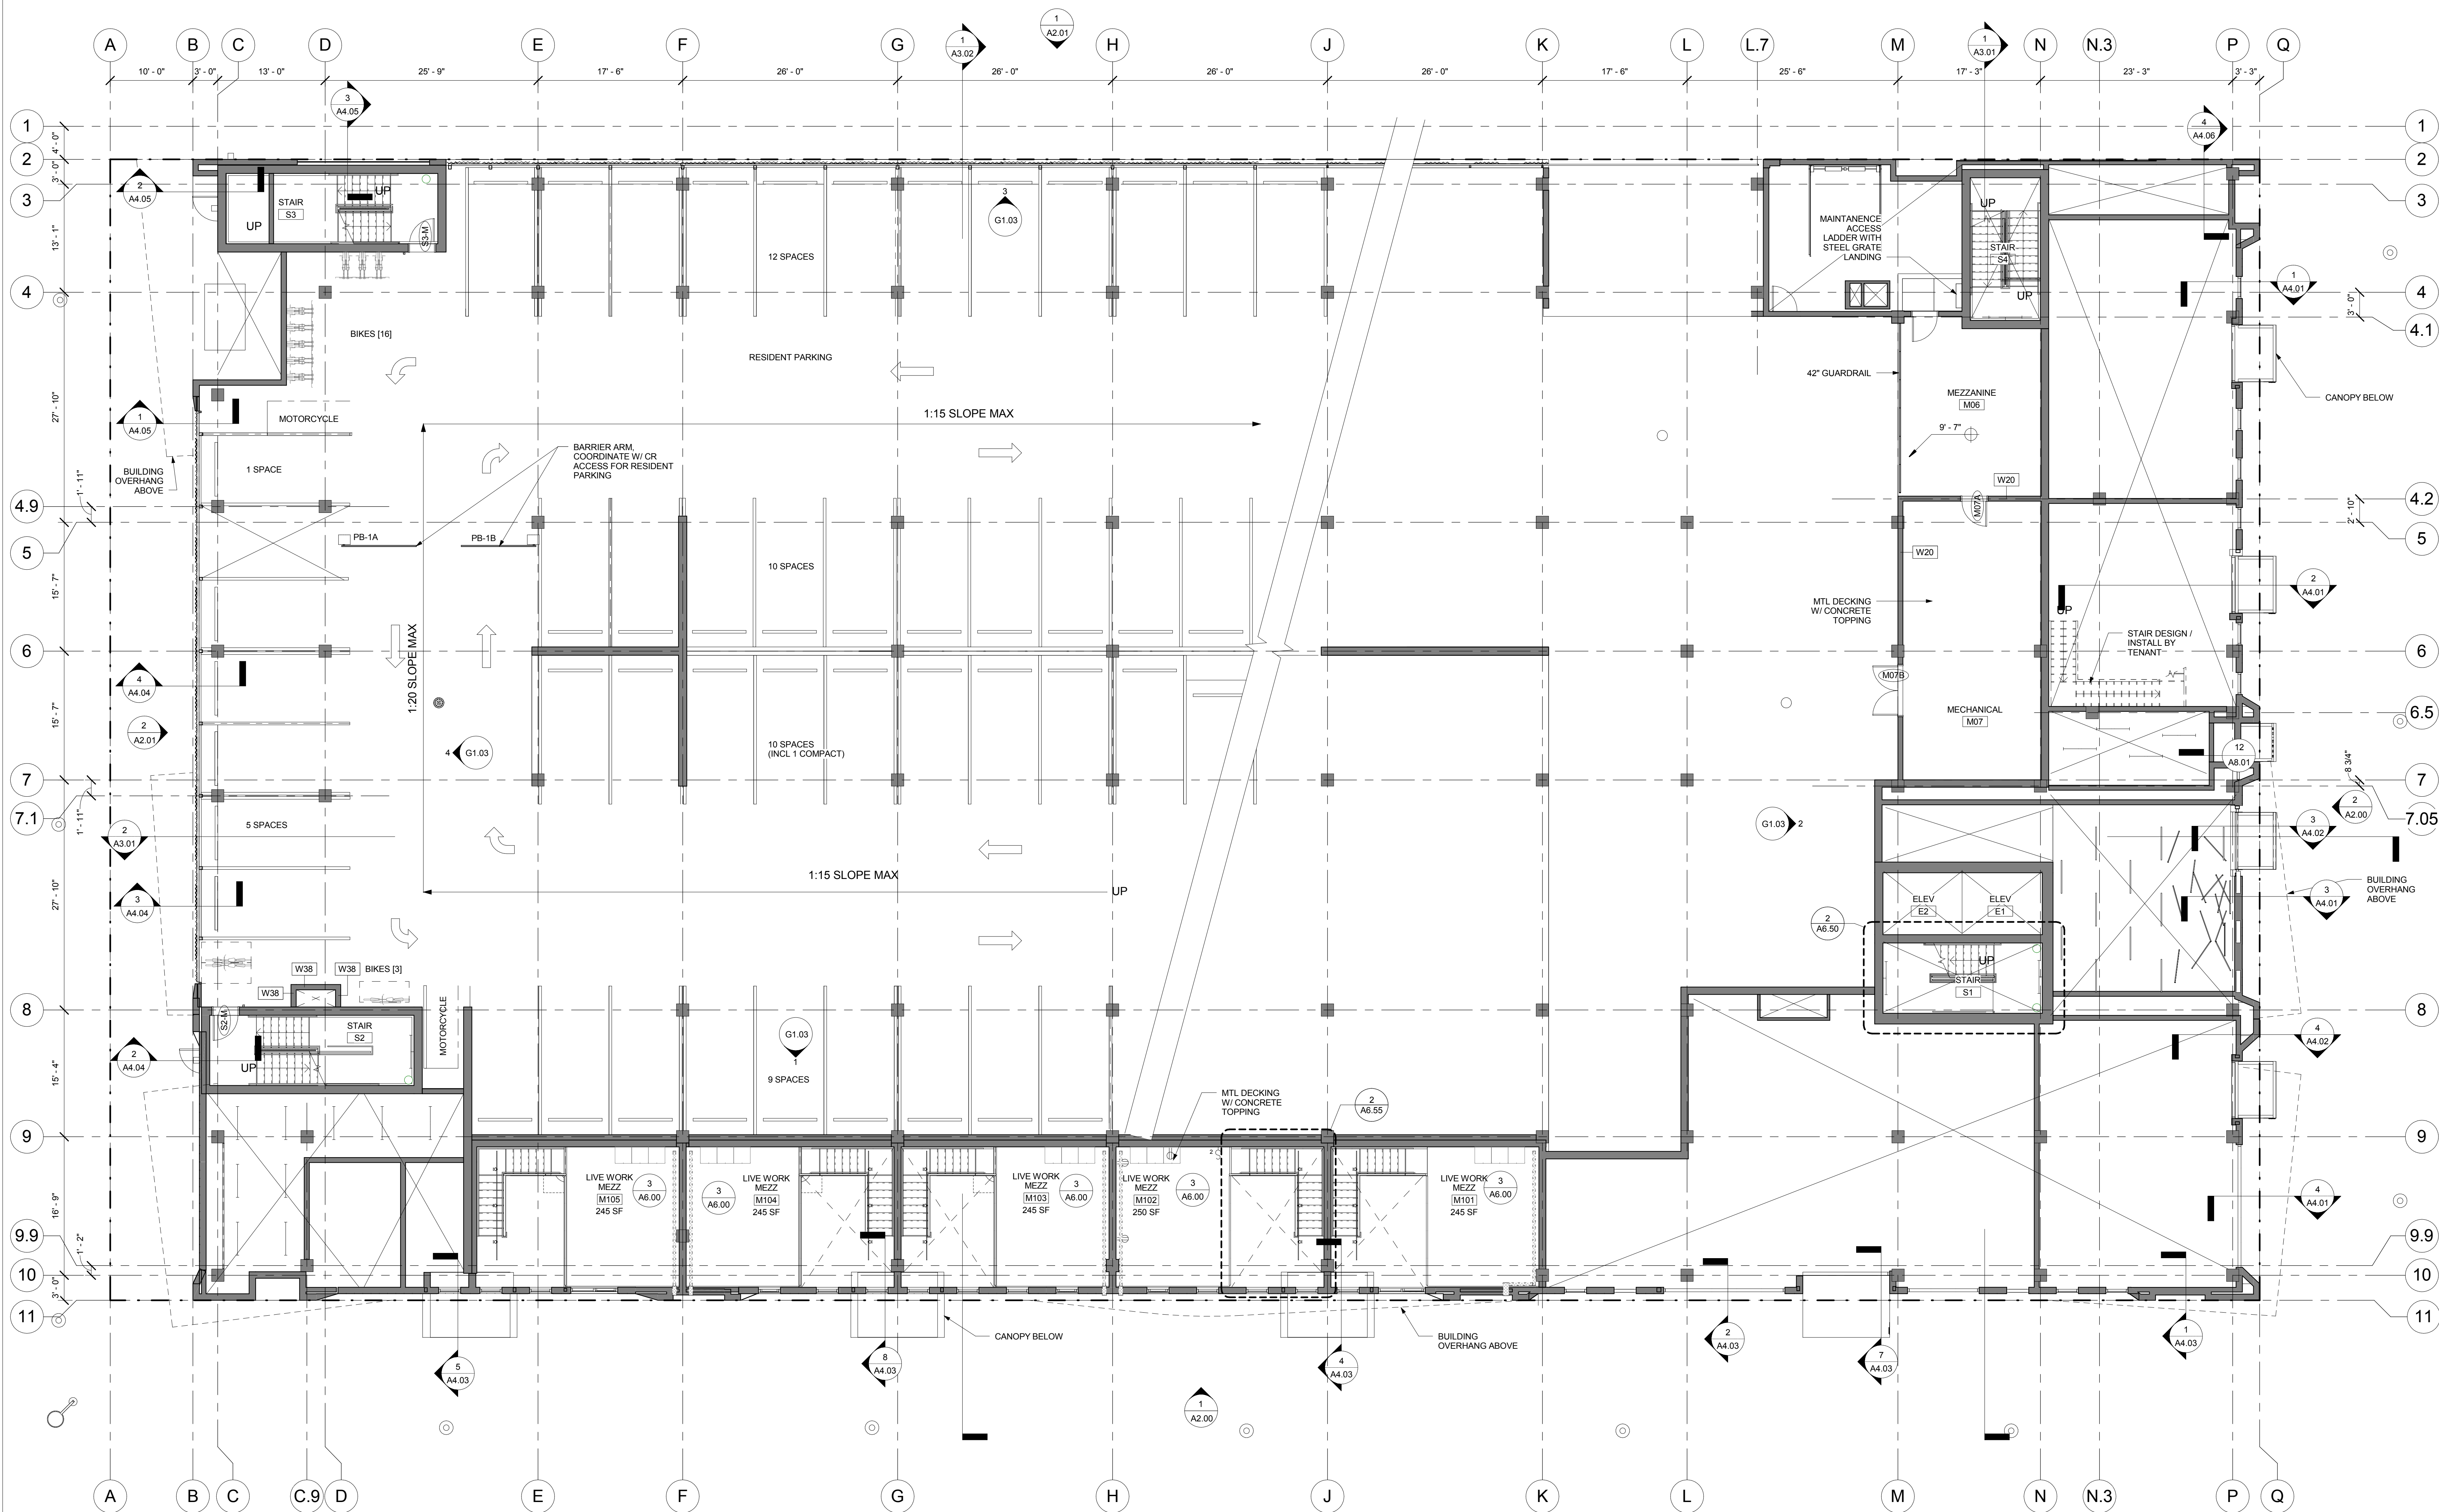

1 MEZZANINE FLOOR PLAN
A1.1M
1/8" = 1'-0"

PROJECT
NORTH

sheet title:


MEZZANINE
FLOOR PLAN

sheet no.:

A1.1M

© 2012 HOLIST ARCHITECTURE pc

12/7/2015 9:51:09 AM

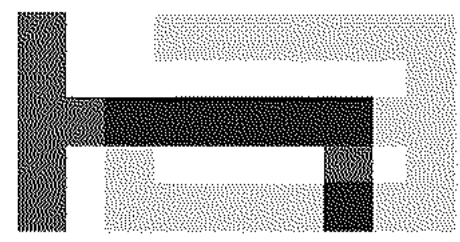

Holst Architecture

110 SE 8th Ave
Portland, OR 97214
www.holstarc.com

5TH & BROAD

401 S 5TH ST
BOISE, ID 83702

JOB NO. 14-111

CONSTRUCTION DOCUMENTS

ISSUE:	DATE:
100% SD	04.14.15
PODIUM PERMIT	06.12.15
100% DD	07.09.15
50% CD	08.20.15
60% CD	09.08.15
75% CD PERMIT	09.18.15

revision list

date:


sheet title:

LEVEL 02 FLOOR PLAN

sheet no.:


A1.02

© 2012 HOLST ARCHITECTURE pc

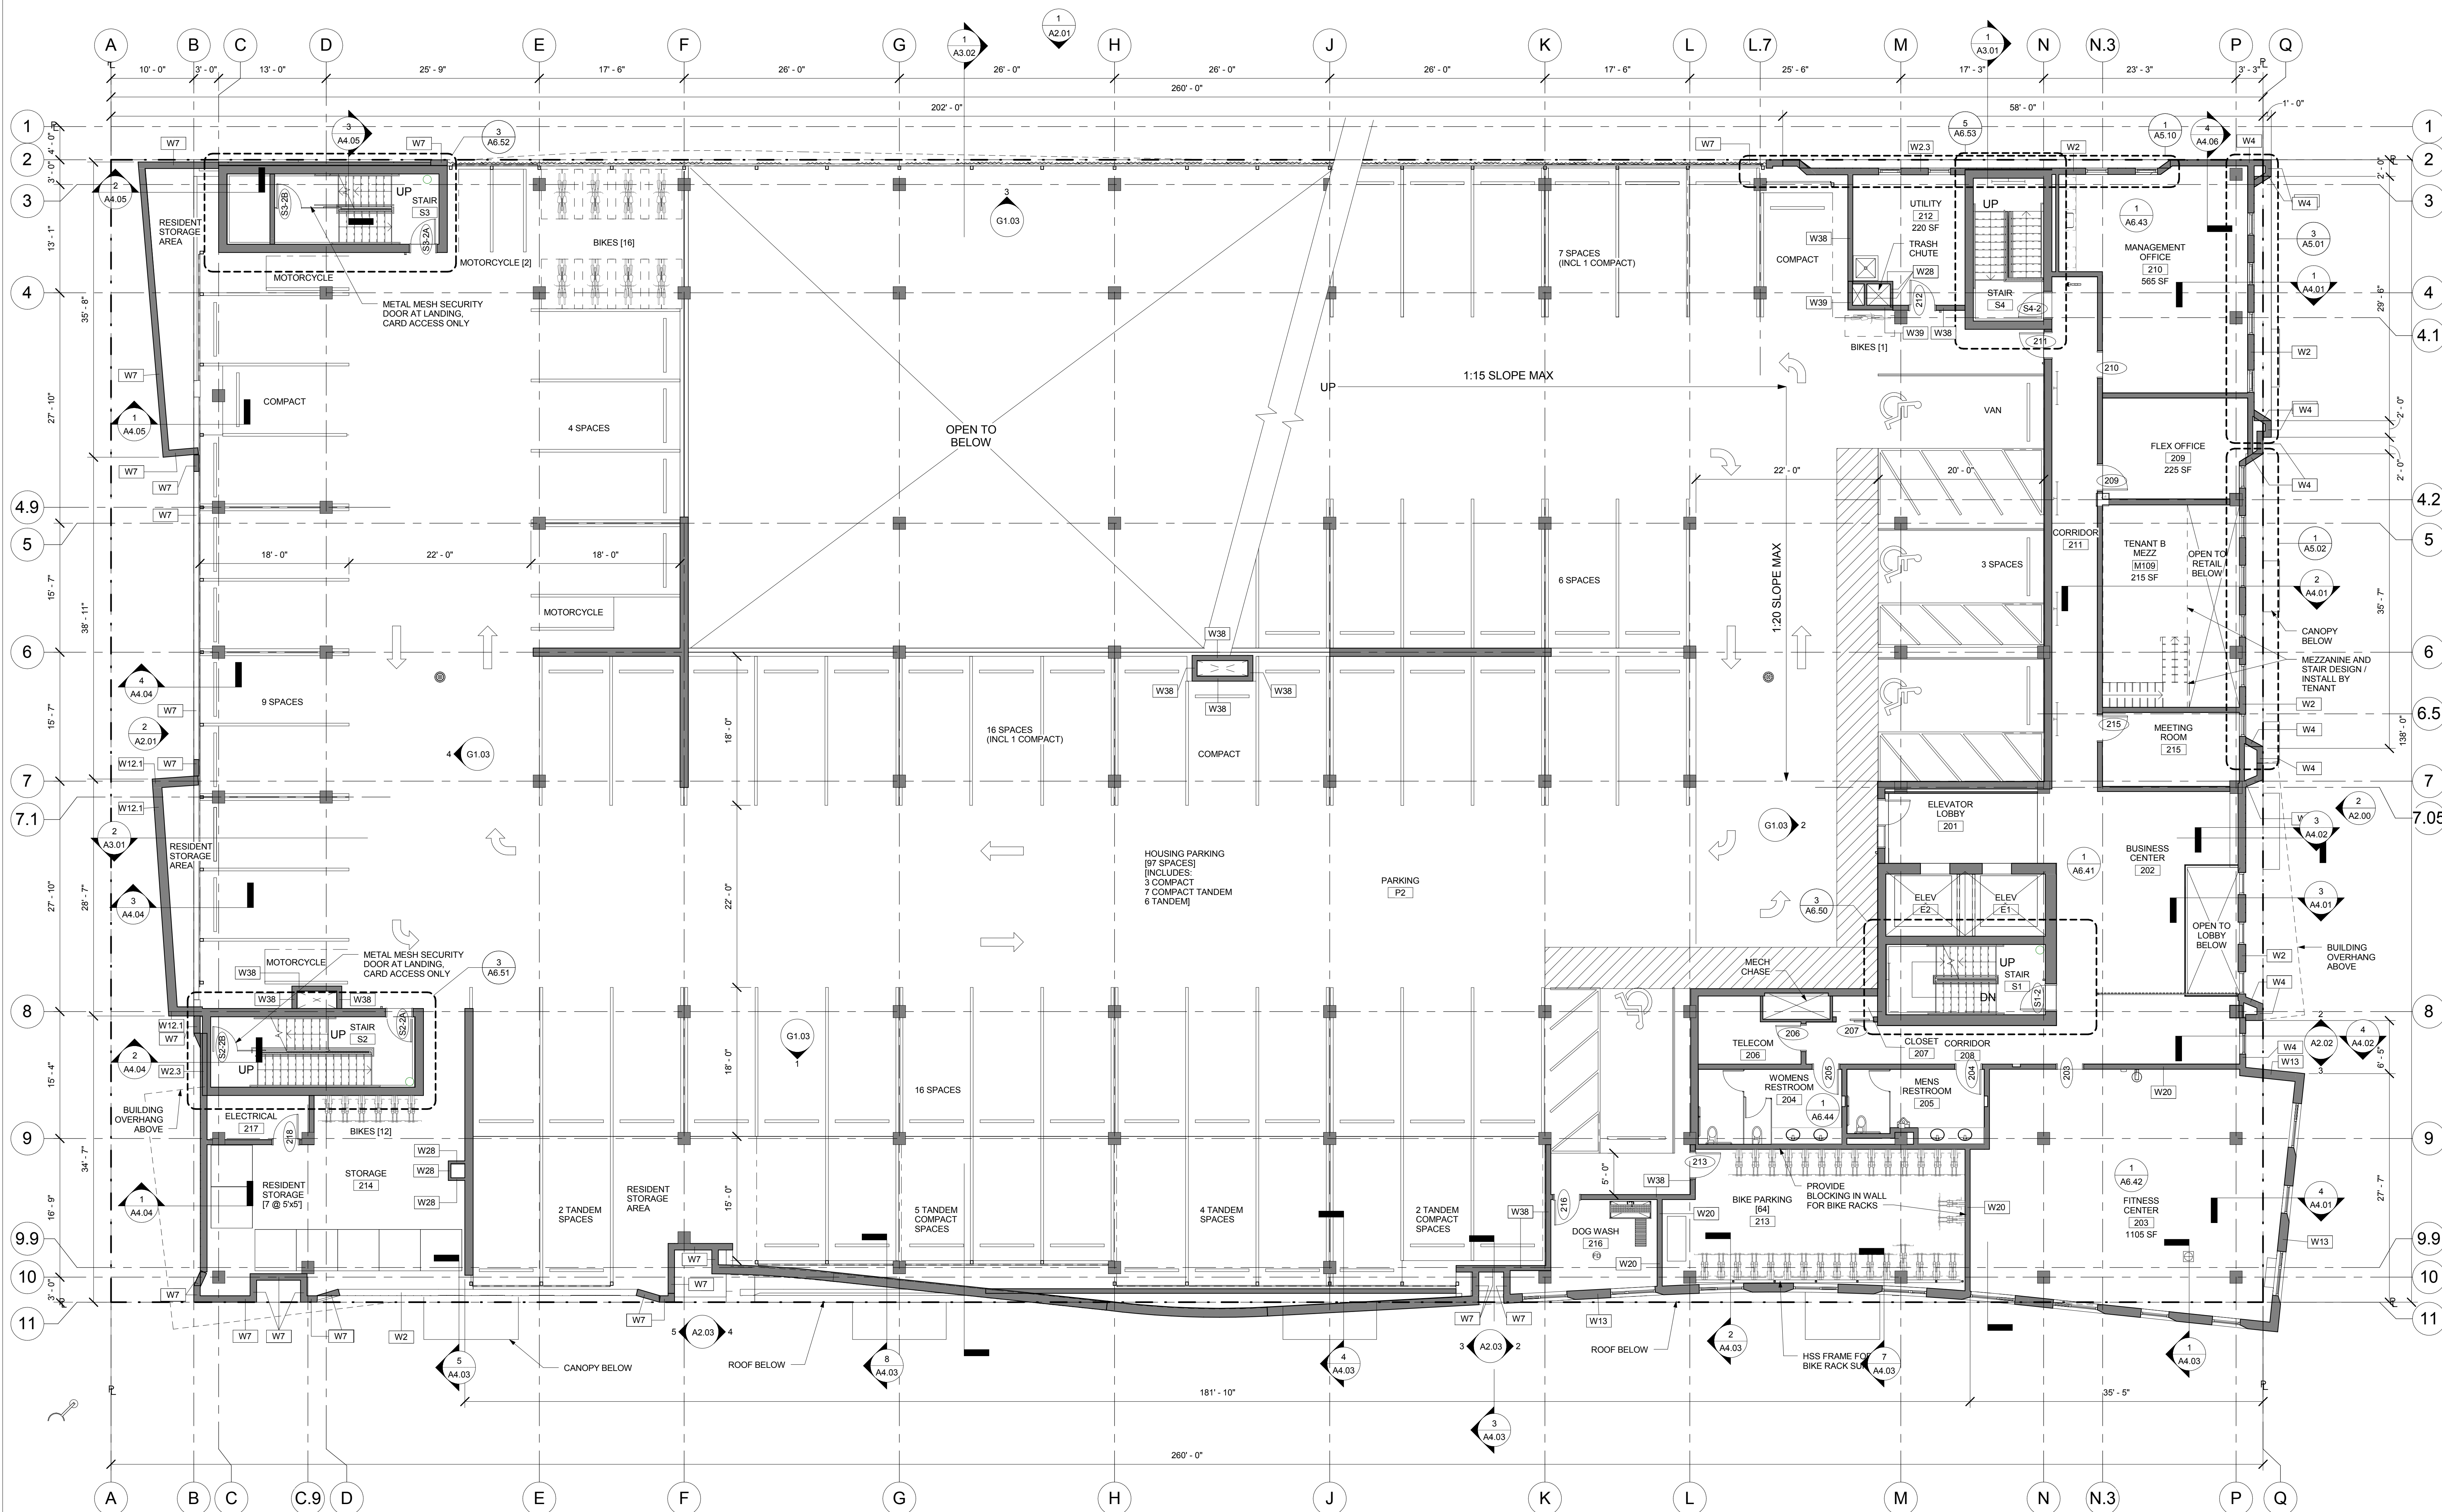

1 LEVEL 02 FLOOR PLAN
1/8" = 1'-0"

PROJECT NORTH

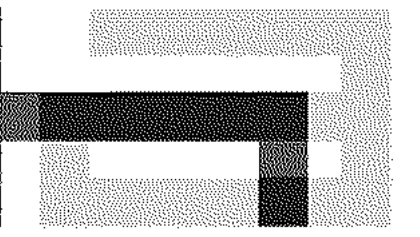

Holst Architecture

110 SE 8th Ave
Portland, OR 97214
www.holstarc.com

5TH & BROAD

401 S 5TH ST
BOISE, ID 83702

JOB NO. 14-111

CONSTRUCTION DOCUMENTS

ISSUE:	DATE:
100% SD	04.14.15
PODIUM PERMIT	06.12.15
100% DD	07.09.15
50% CD	08.20.15
60% CD	09.08.15
75% CD PERMIT	09.18.15

revision list

date:


sheet title:

LEVEL 03 FLOOR PLAN

sheet no.:

A1.03


© 2012 HOLST ARCHITECTURE pc

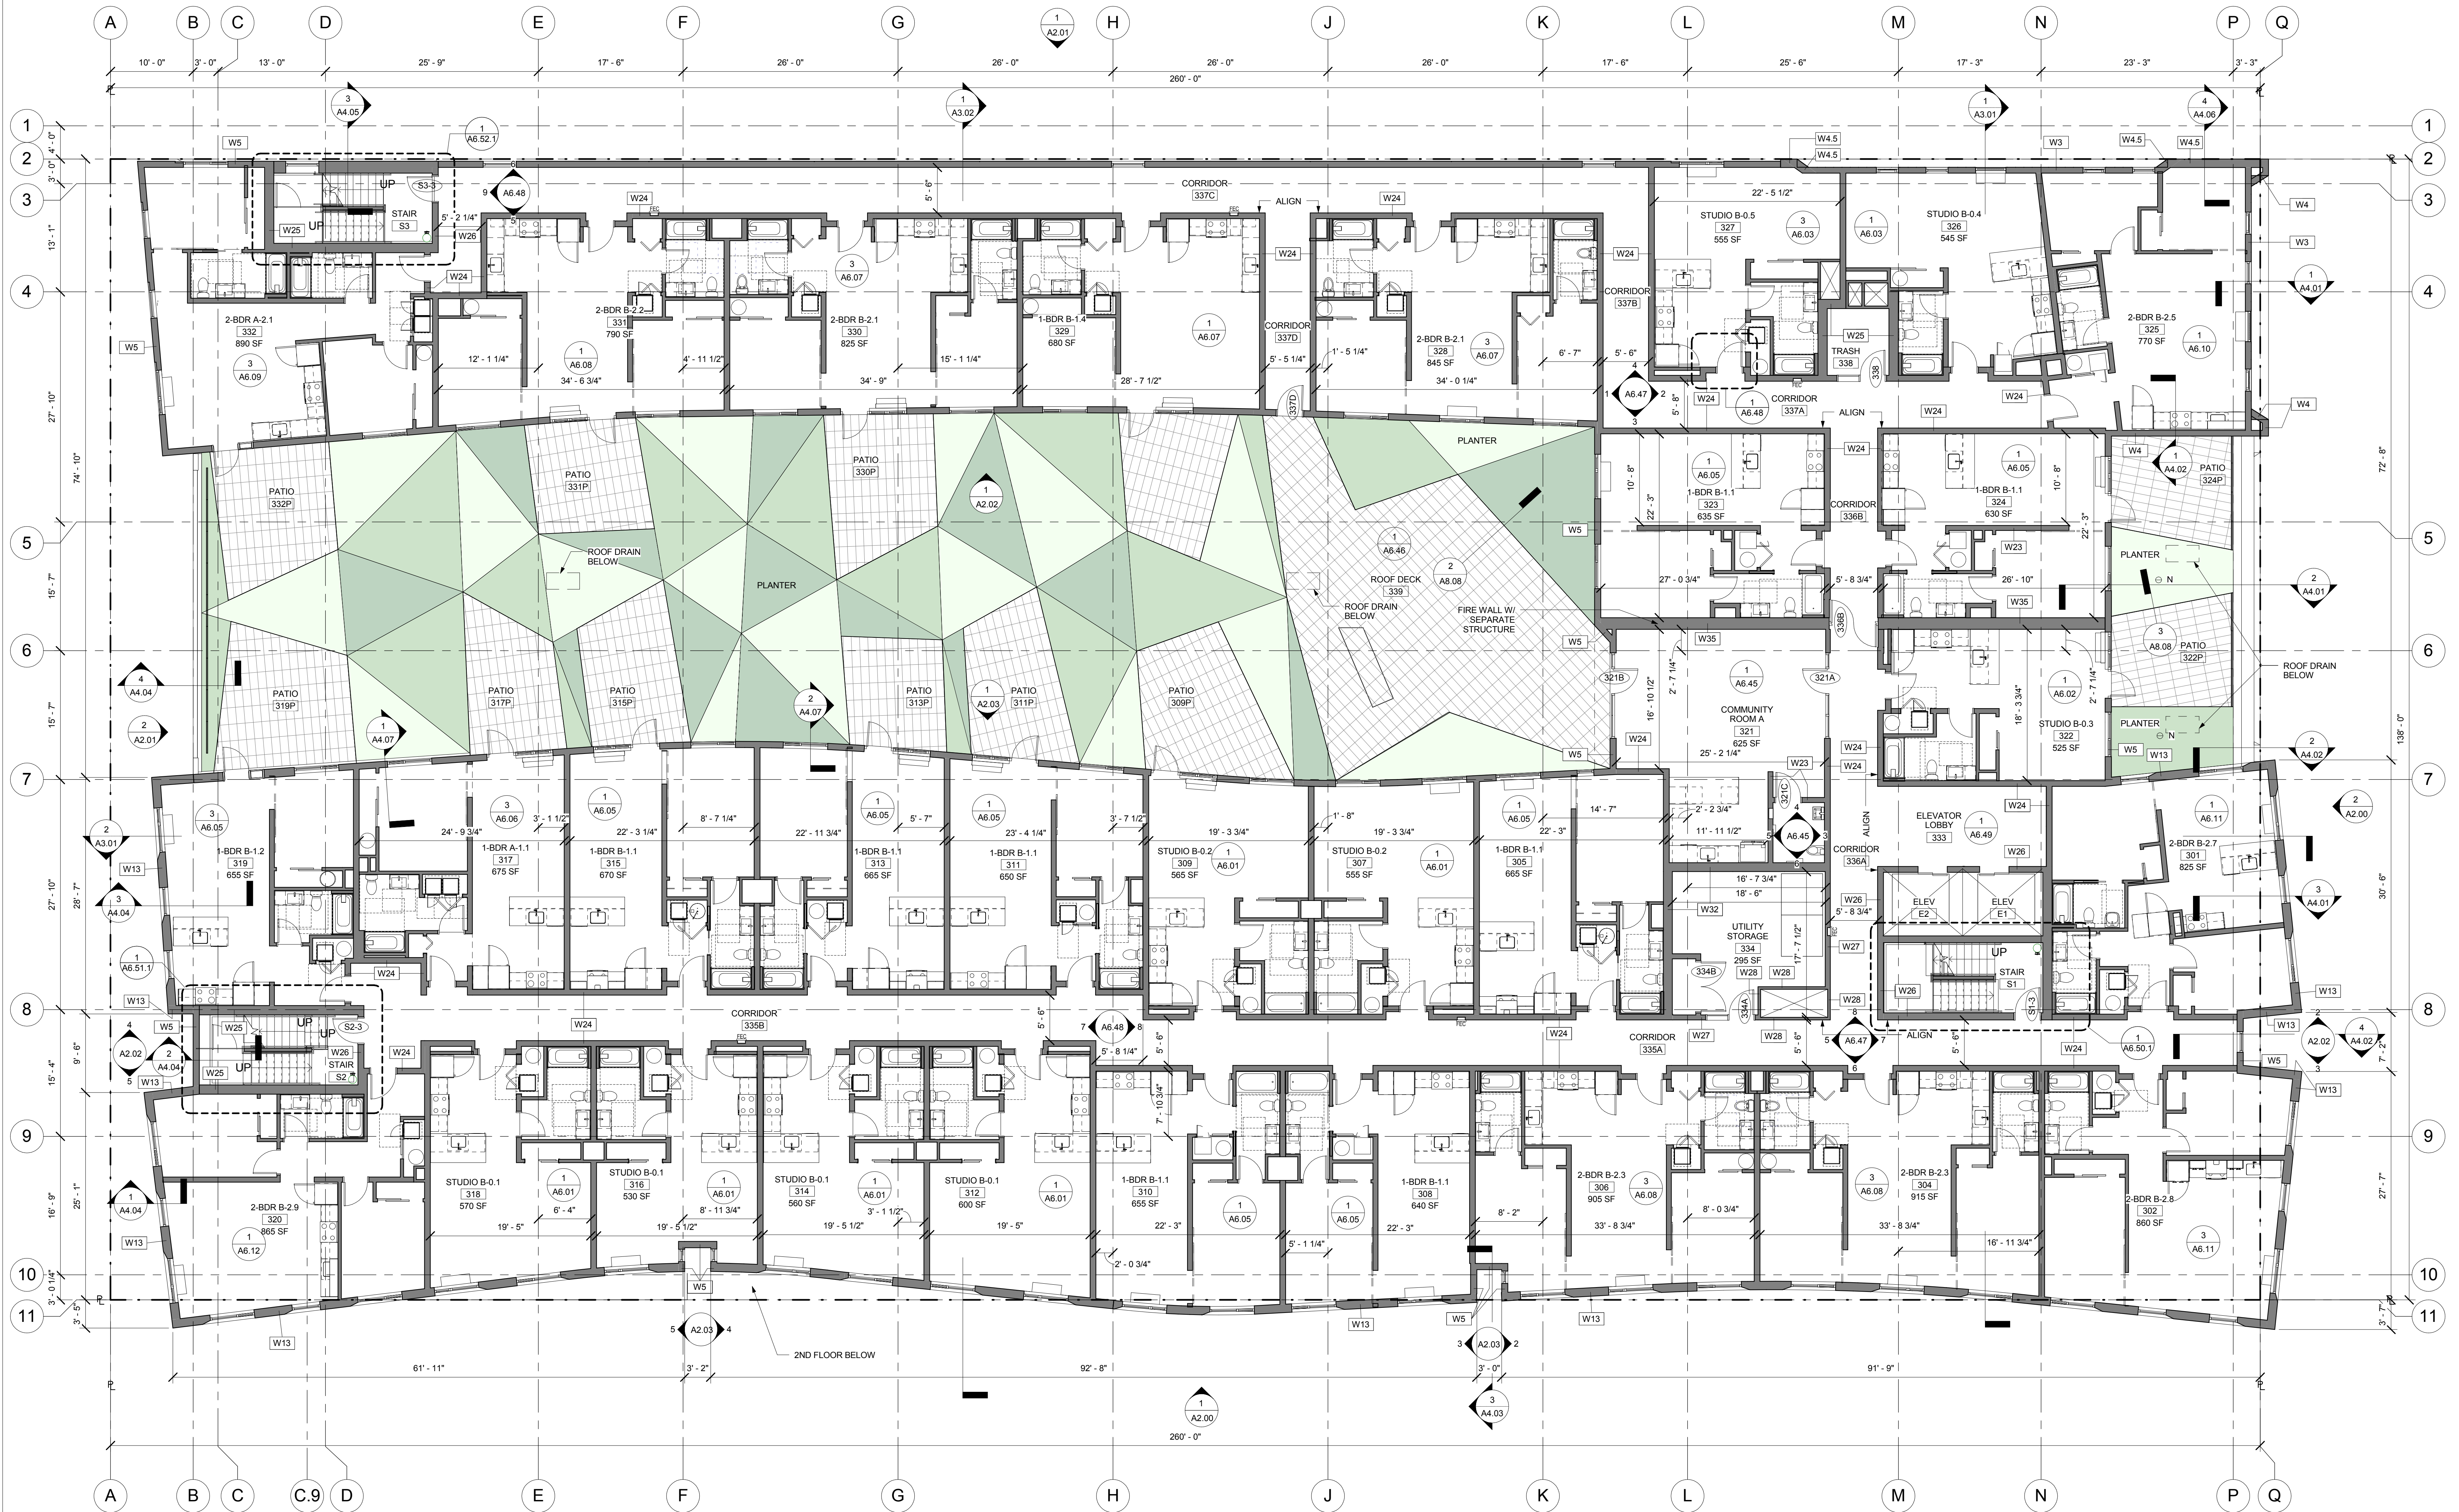

1 LEVEL 03 FLOOR PLAN
A1.03 1/8" = 1'-0"



PROJECT
NORTH

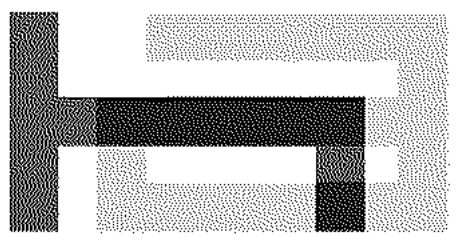

Holst Architecture

110 SE 8th Ave
Portland, OR 97214
www.holstarc.com

5TH & BROAD


401 S 5TH ST
BOISE, ID 83702

JOB NO. 14-111

CONSTRUCTION DOCUMENTS

ISSUE:	DATE:
100% SD	04.14.15
PODIUM PERMIT	06.12.15
100% DD	07.09.15
50% CD	08.20.15
60% CD	09.08.15
75% CD PERMIT	09.18.15

revision list date:

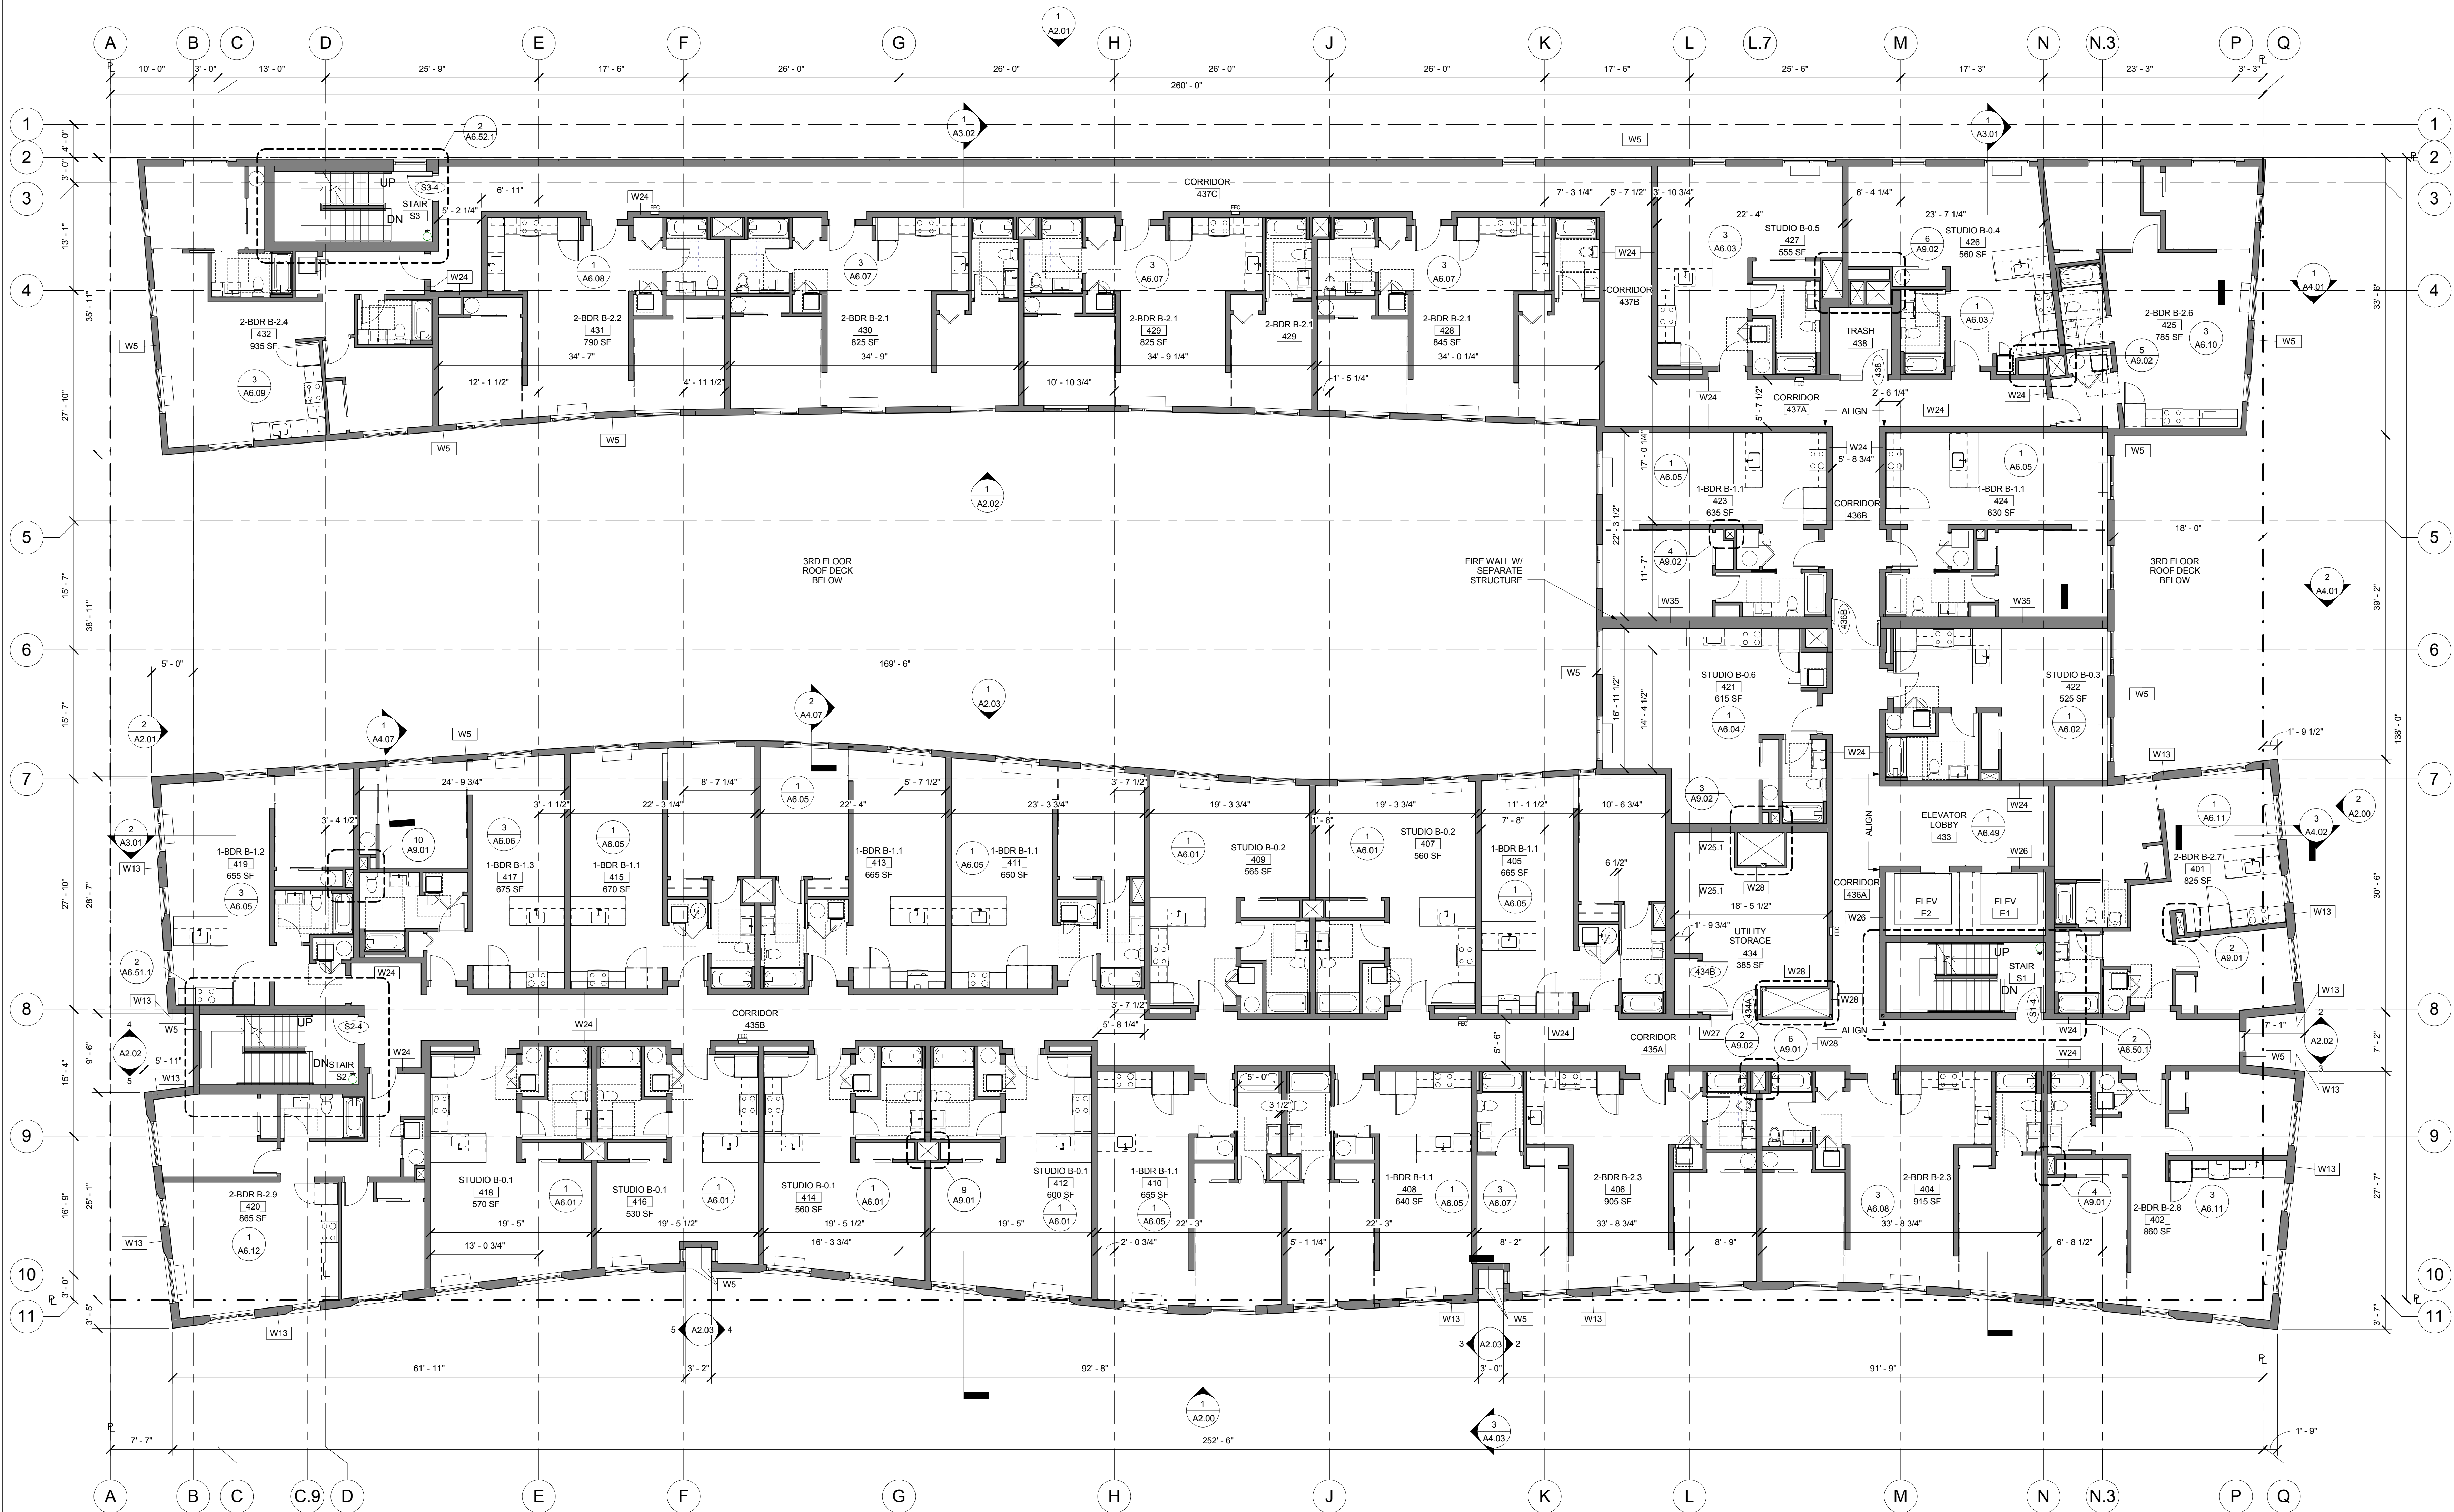

1 LEVEL 04-07 FLOOR PLAN
A1.04 1/8" = 1'-0"

PROJECT
NORTH

sheet title:

LEVEL 04 FLOOR
PLAN

sheet no.:

A1.04

© 2012 HOLST ARCHITECTURE pc



5TH & BROA

JOB NO. 14-

**CONSTRUCTION
DOCUMENT**

issue:	d
100% SD	04.14
PODIUM PERMIT	06.12
100% DD	07.05
50% CD	08.20
60% CD	09.08
75% CD PERMIT	09.18

revision list

sheet 1

EXTERIOR
BUILDING
ELEVATION

sheet

A2.00



© 2012 HOLST ARCHITECTURE



MATERIAL LEGEND / NOTES


ST-1	INTEGRAL COLOR ACRYLIC STUCCO, WITH CUSTOM TEXTURE FINISH, CUSTOM COLOR
ST-2	"FREESTYLE" SMOOTH FINISH, INTEGRAL COLOR ACRYLIC STUCCO, CUSTOM COLOR
ST-3	"FREESTYLE" SMOOTH FINISH, INTEGRAL COLOR ACRYLIC STUCCO, STANDARD WHITE
MP-1	PRE-FINISHED KYNAR COATED ALUMINUM WALL PANEL
MP-1-2	PRE-FINISHED KYNAR COATED ALUMINUM WALL PANEL, PERFORATED
MP-2	PAINTED 1/4" STEEL PLATE OVER HSS FRAME
SF-1	ALUMINUM STOREFRONT, SSG (STRUCTURAL SILICONE GLAZED VERTICALS), PAINTED KYNAR FINISH
BV-1	BRICK VENEER
DRV-1	COMMERCIAL GRADE, FACTORY MULLED VINYL SWINGS DOOR W/ SIDELITE & TRANSOM
WND-1	COMMERCIAL GRADE VINYL WINDOW
WND-2	THERMAL ALUMINUM GLASS VENT FOR STOREFRONT
MF-1	20 GA PRE-FINISHED METAL FLASHING TM FINISH
MF-2	20 GA PRE-FINISHED METAL FLASHING TM FINISH
MS-1	PERFORATED ALUMINUM V PANEL, PRE-FINISHED KYNAR PAINTED, STANDARD WHITE
MS-2	PERFORATED STEEL PLATE, PRE-FINISHED KYNAR PAINTED, STANDARD WHITE
T	TEMPERED GLASS
VCJ	VERTICAL CONTROL JOINT
H CJ	HORIZONTAL CONTROL JOINT, TYPICAL AT EACH WINDOW HEAD

12/7/2015 12:11:42 PM

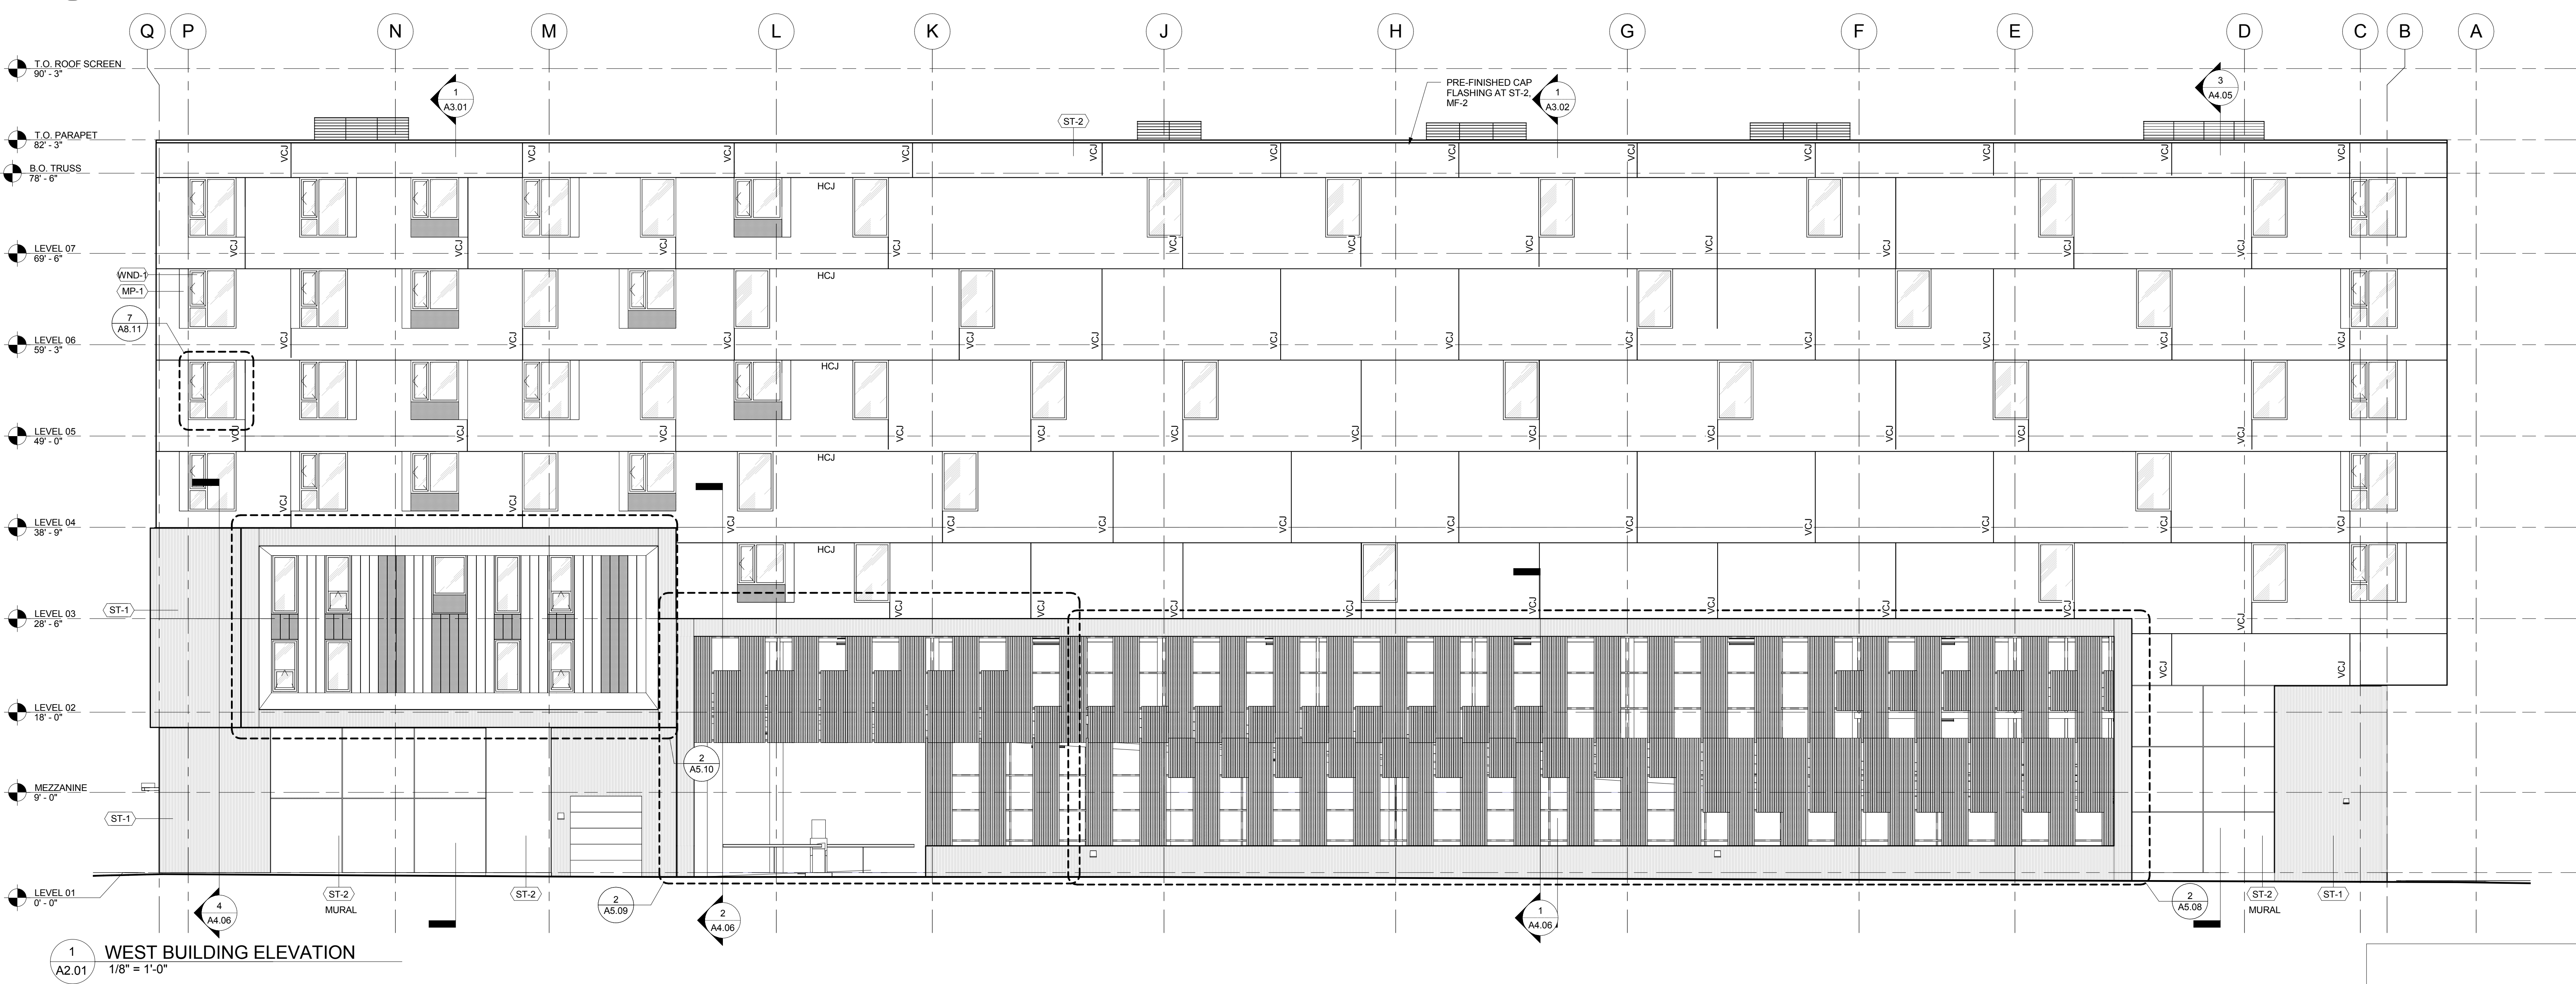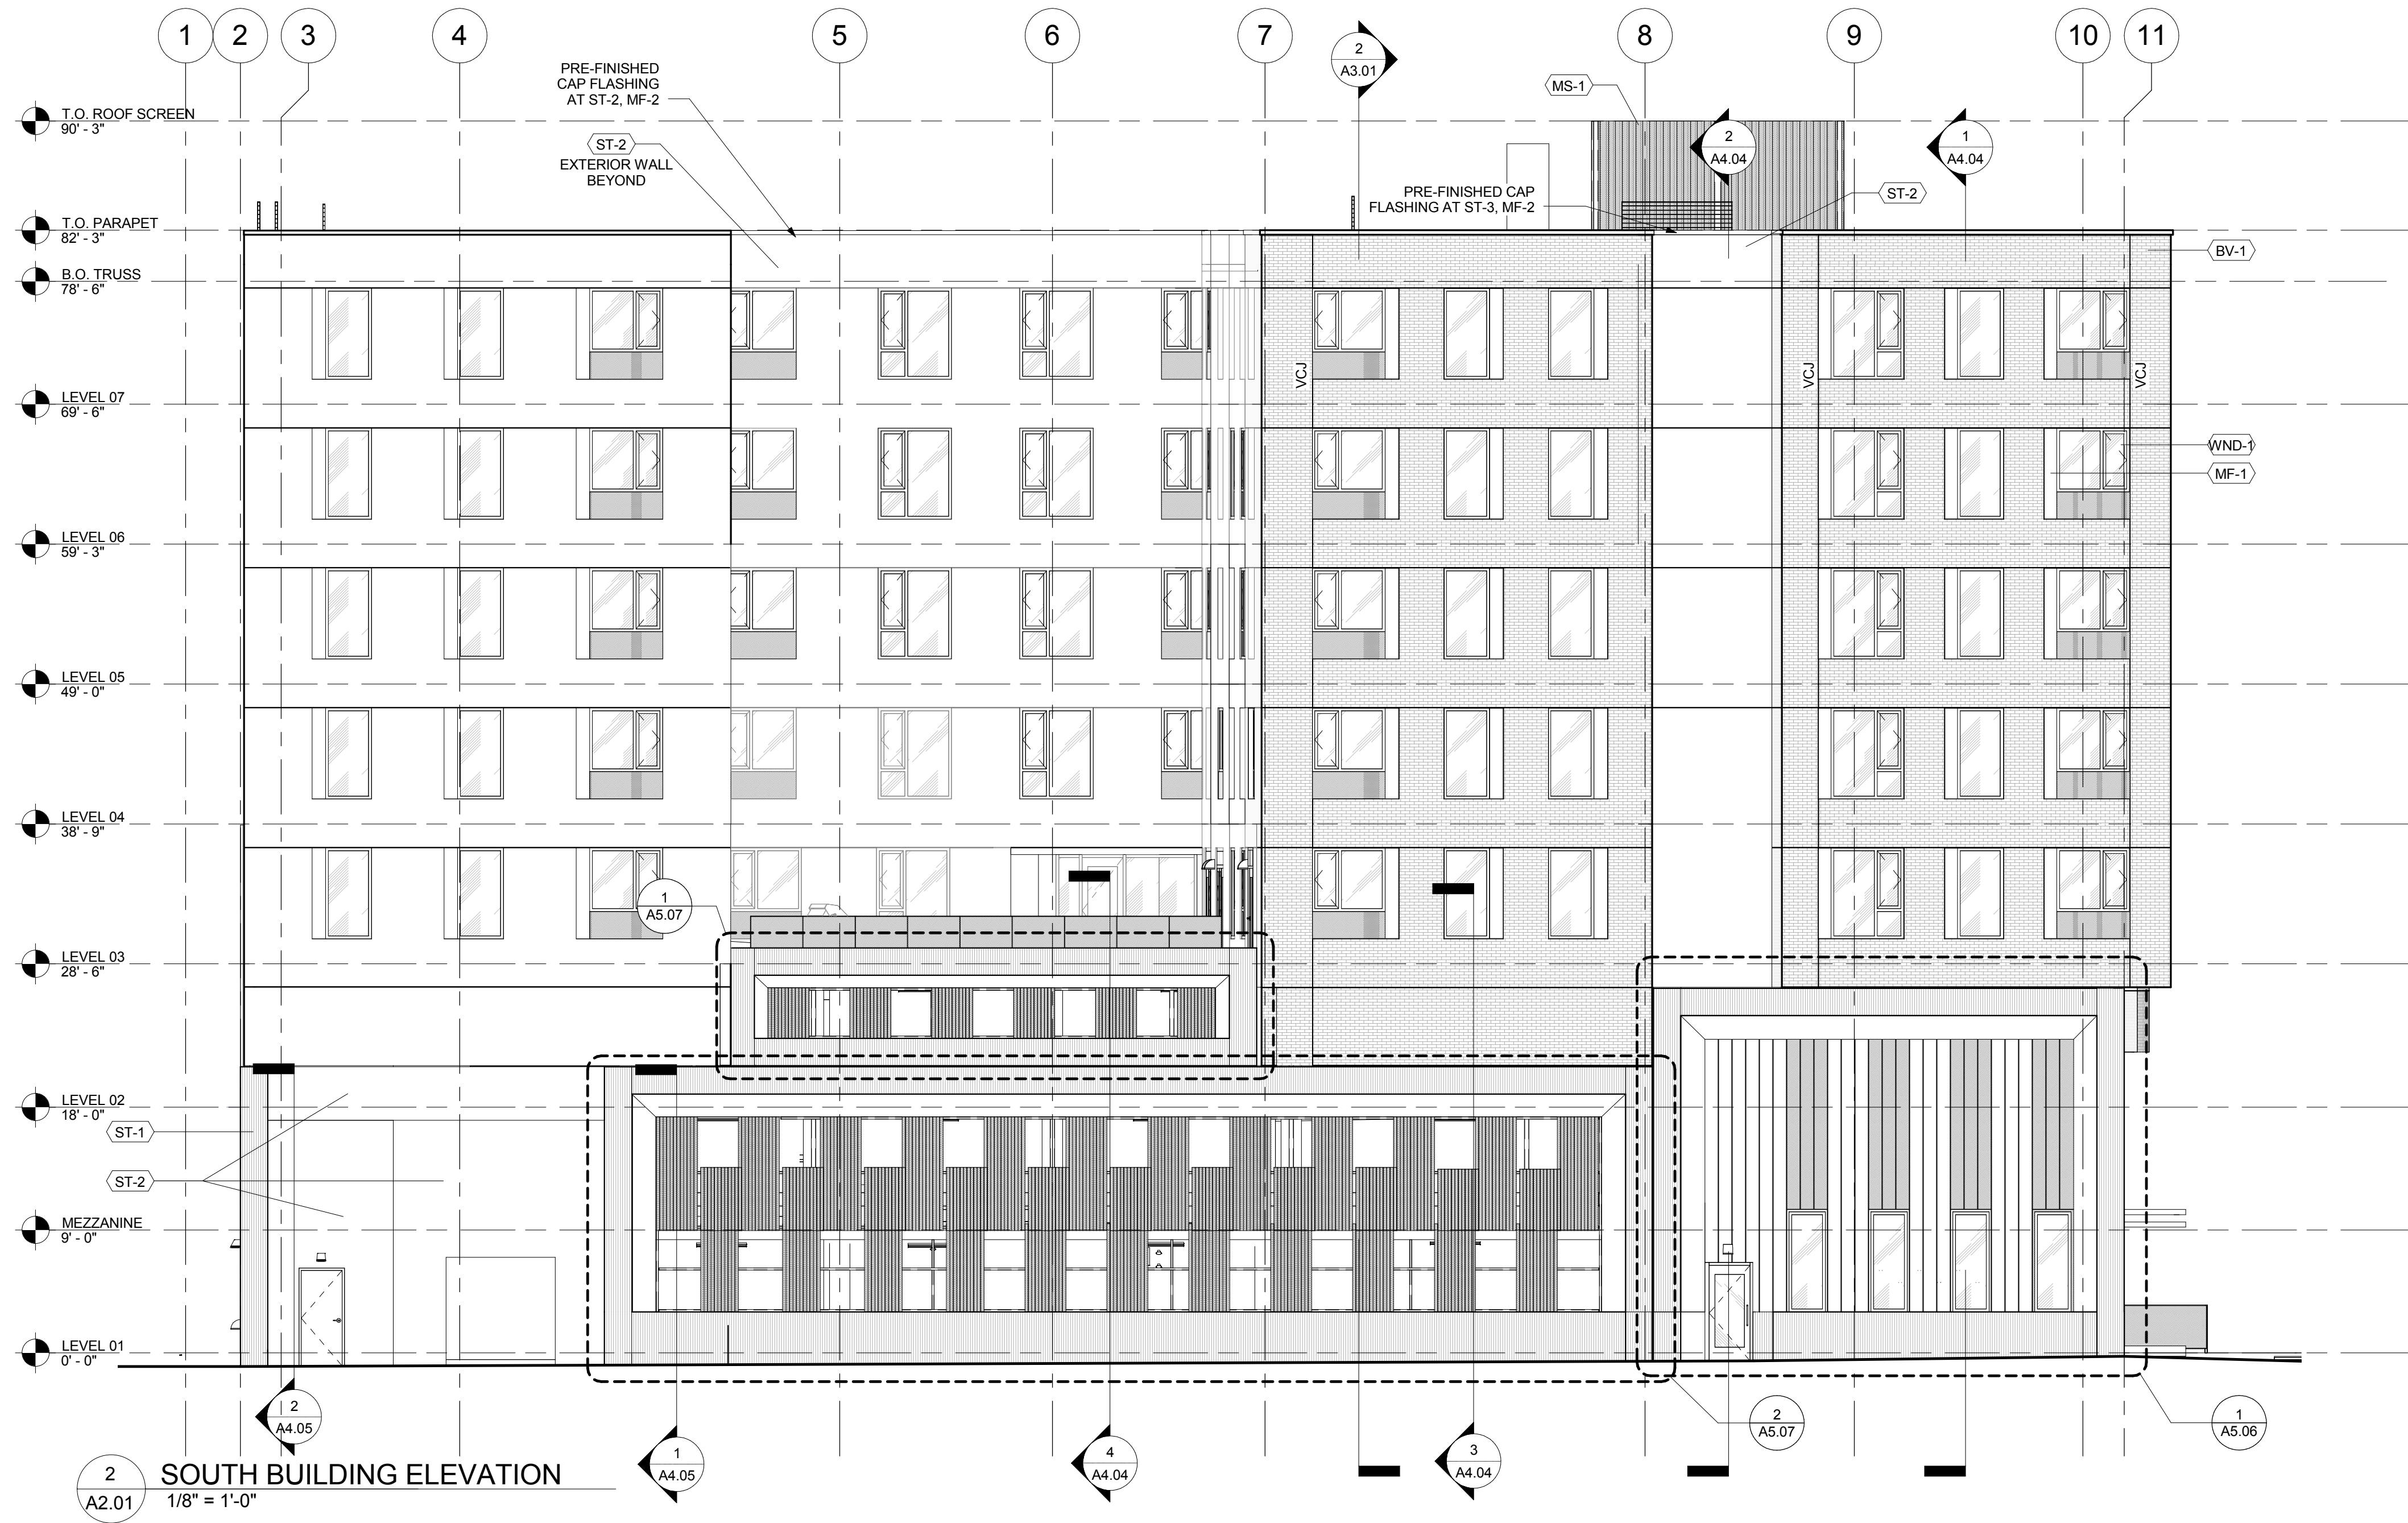

MATERIAL LEGEND / NOTES

- (ST-1) INTEGRAL COLOR ACRYLIC STUCCO, WITH CUSTOM TEXTURE FINISH, CUSTOM COLOR
- (ST-2) "FREESTYLE" SMOOTH FINISH, INTEGRAL COLOR ACRYLIC STUCCO, CUSTOM COLOR
- (ST-3) "FREESTYLE" SMOOTH FINISH, INTEGRAL COLOR ACRYLIC STUCCO, STANDARD WHITE
- (MP-1) PRE-FINISHED KYNAR COATED ALUMINUM WALL PANEL
- (MP-1.2) PRE-FINISHED KYNAR COATED ALUMINUM WALL PANEL, PERFORATED
- (MP-2) PAINTED 1/4" STEEL PLATE OVER HSS FRAME
- (SF-1) ALUMINUM STOREFRONT, SSG (STRUCTURAL SILICONE GLAZED VERTICALS), PAINTED KYNAR FINISH
- (BV-1) BRICK VENEER
- (DRV-1) COMMERCIAL GRADE, FACTORY MULLED VINYL SWING DOOR W/ SIDELITE & TRANSOM
- (WND-3) COMMERCIAL GRADE VINYL WINDOW
- (WND-2) THERMAL ALUMINUM GLASS VENT FOR STOREFRONT
- (MF-1) 20 GA PRE-FINISHED METAL FLASHING T/M MP-1
- (MF-2) 20 GA PRE-FINISHED METAL FLASHING T/M ST-2
- (MS-1) PERFORATED ALUMINUM "V" PANEL, PRE-FINISHED KYNAR PAINTED, STANDARD WHITE
- (MS-2) PERFORATED STEEL PLATE, PRE-FINISHED KYNAR PAINTED, STANDARD WHITE
- (T) TEMPERED GLASS
- (VCJ) VERTICAL CONTROL JOINT
- (HCJ) HORIZONTAL CONTROL JOINT, TYPICAL AT EACH WND-1 HEAD

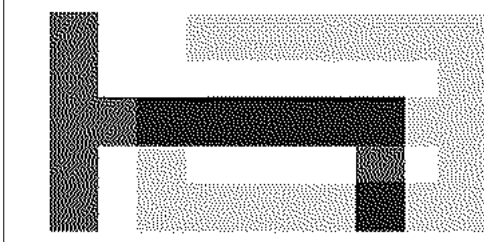

Holist Architecture

110 SE 8th Ave
Portland, OR 97214
www.holistarc.com

5TH & BROAD

401 S 5TH ST
BOISE, ID 83702

JOB NO. 14-111

CONSTRUCTION DOCUMENTS

issue:	date:
100% SD	04.14.15
PODIUM PERMIT	06.12.15
100% DD	07.09.15
50% CD	08.20.15
60% CD	09.08.15
75% CD PERMIT	09.18.15

revision list date:

sheet title:


EXTERIOR
BUILDING
ELEVATIONS

sheet no.:


A2.01

© 2012 HOLIST ARCHITECTURE pc


12/7/2015 12:16:46 PM

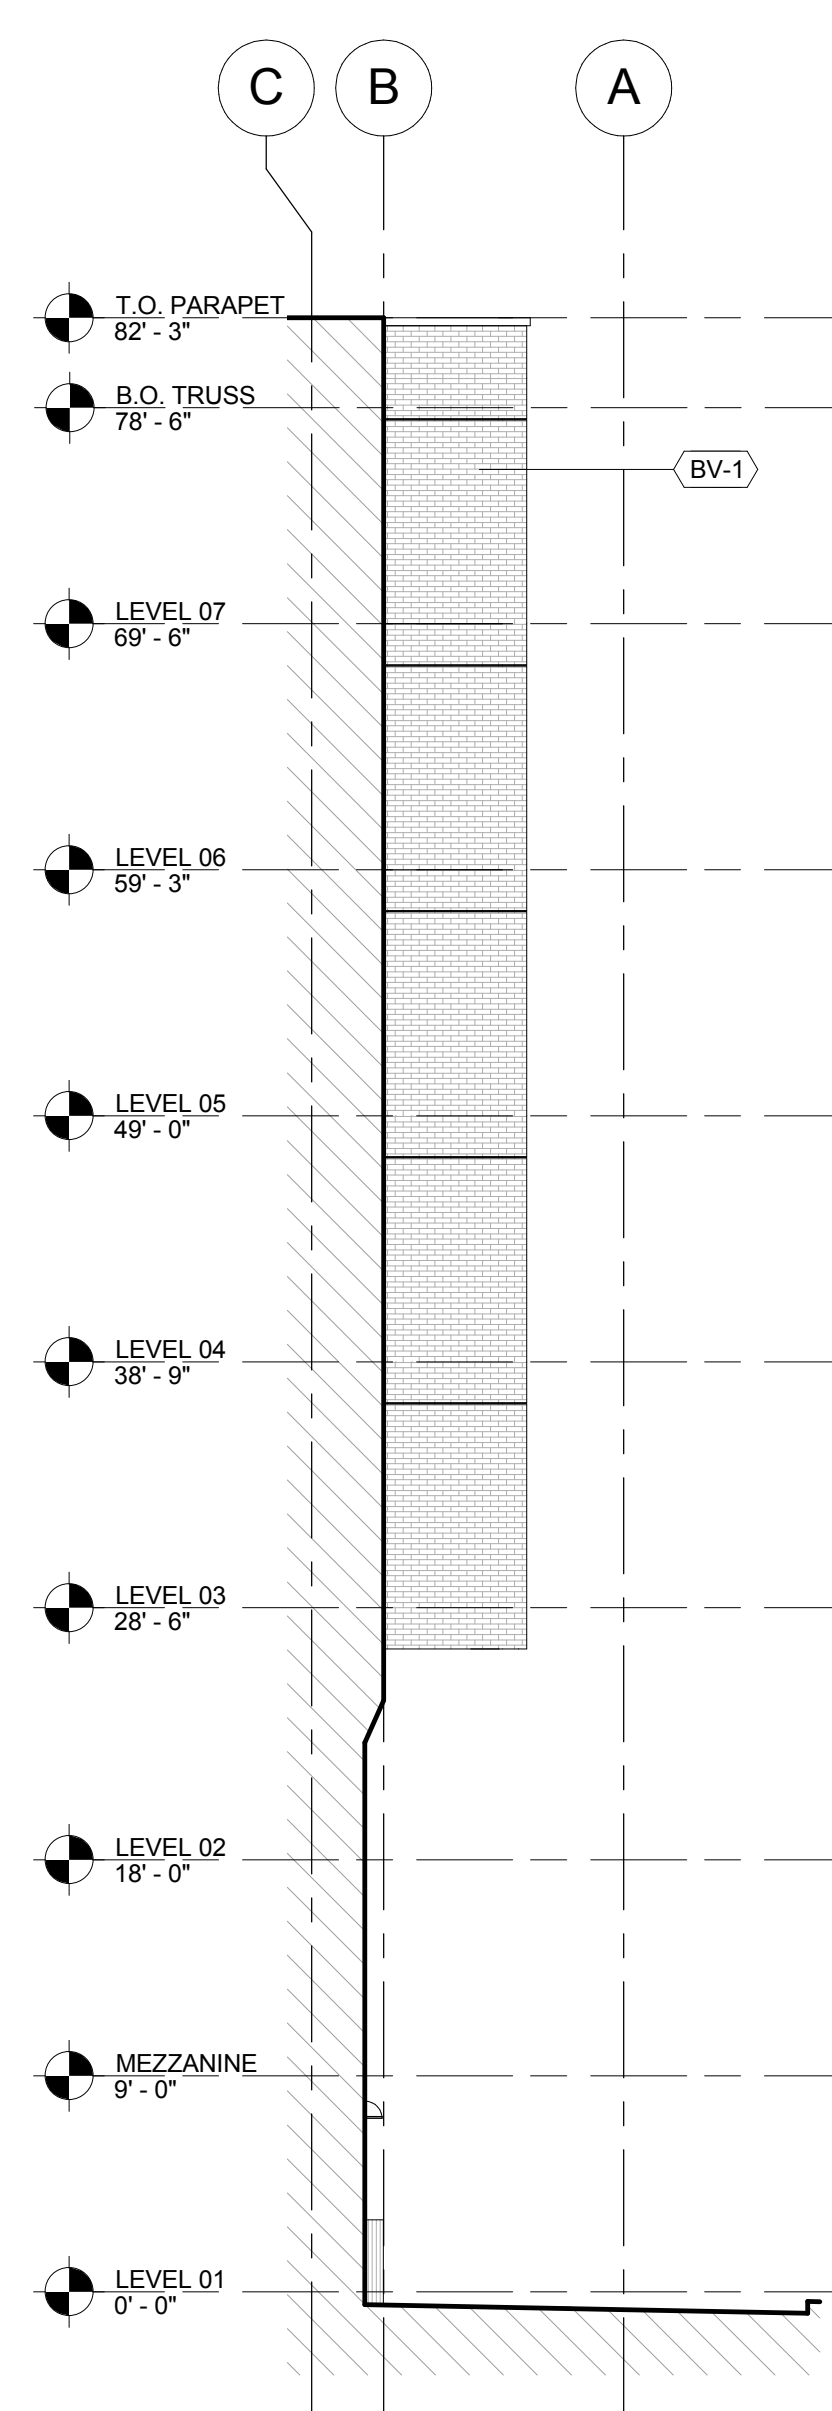


5 EAST ELEVATION AT SOUTH STAIR INSET
A2.02 1/8" = 1'-0"

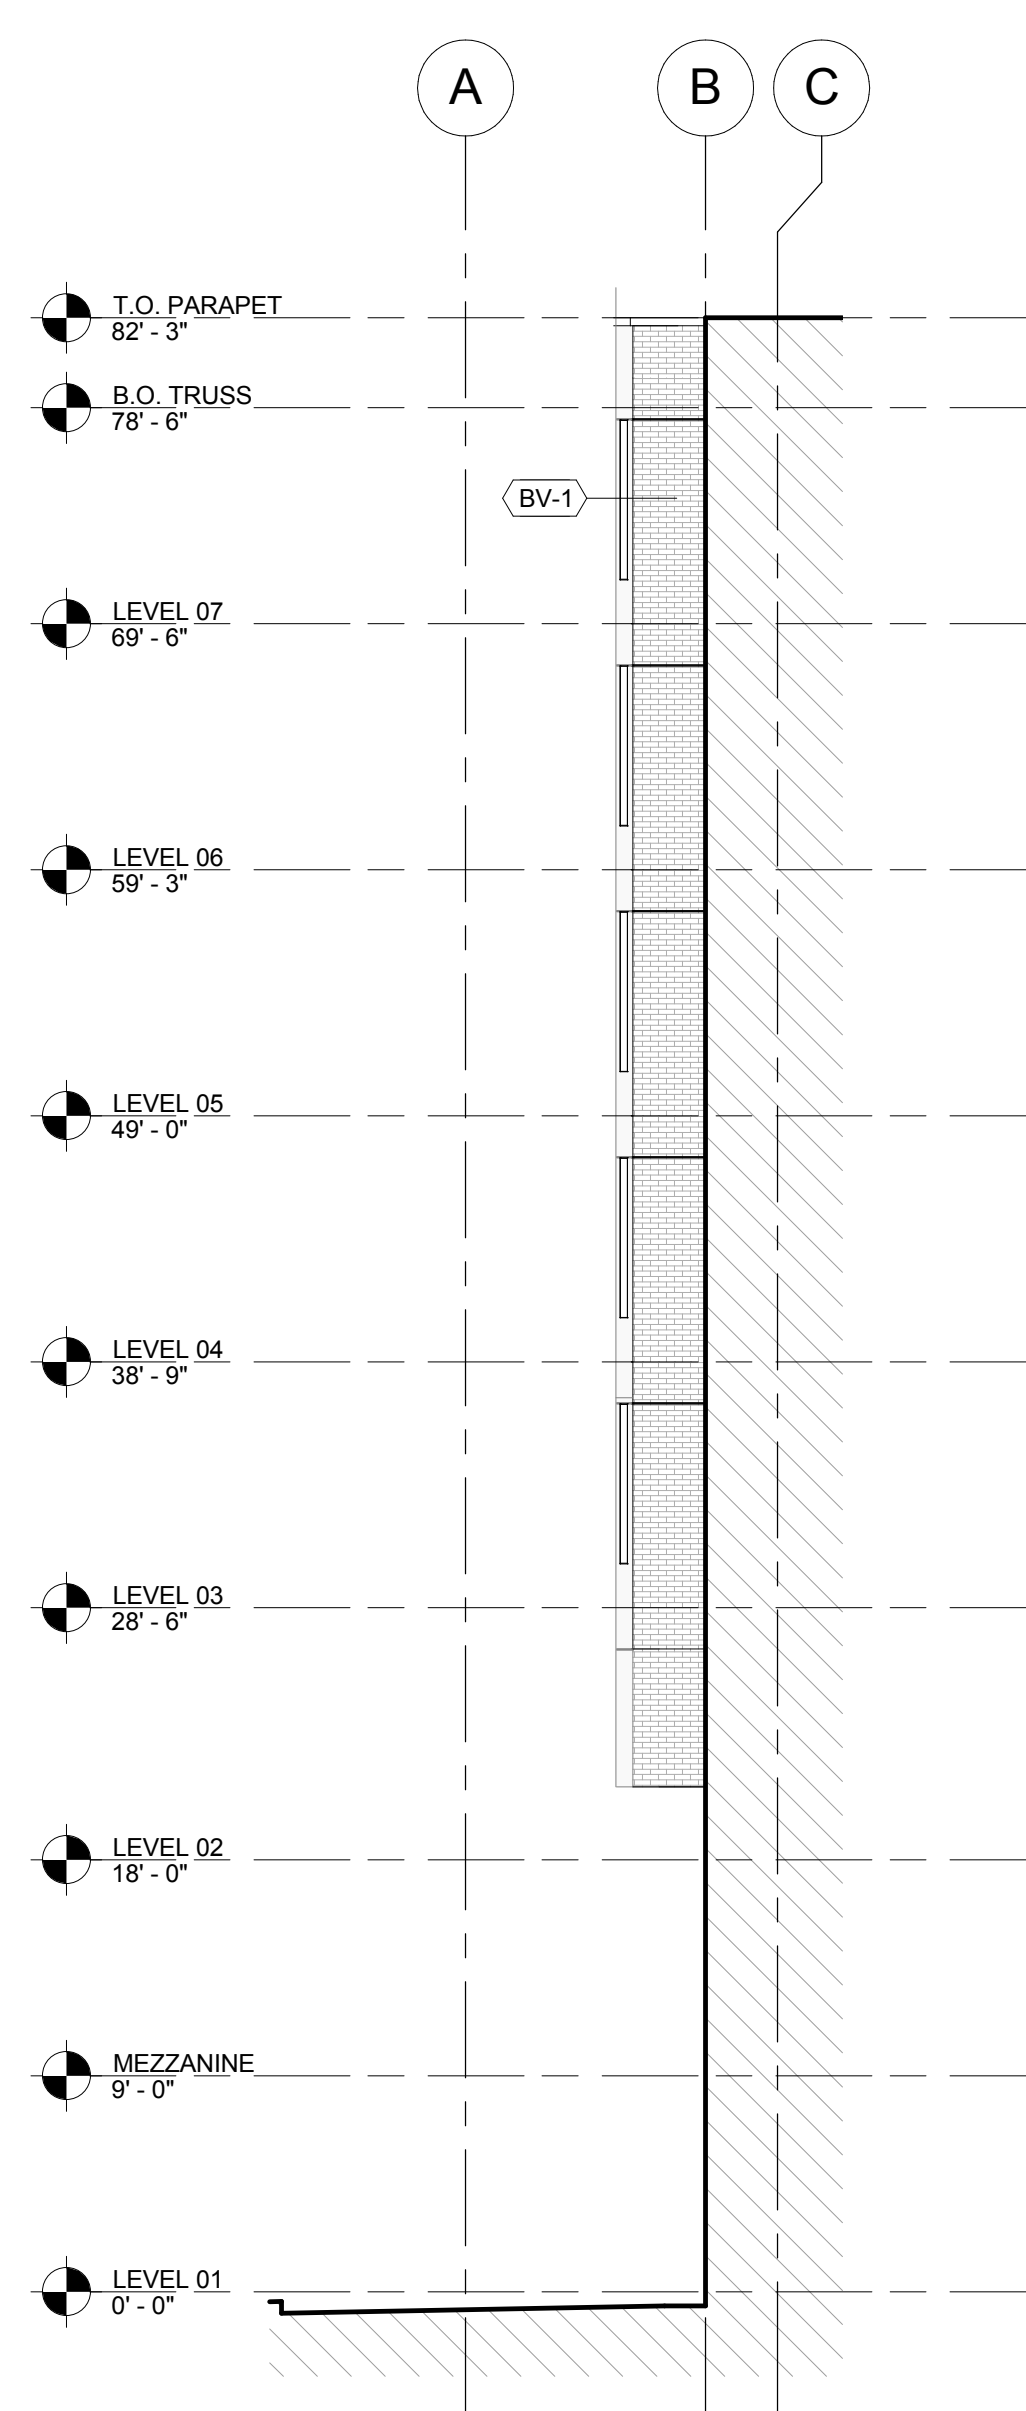


4 WEST ELEVATION AT SOUTH STAIR INSET
A2.02 1/8" = 1'-0"

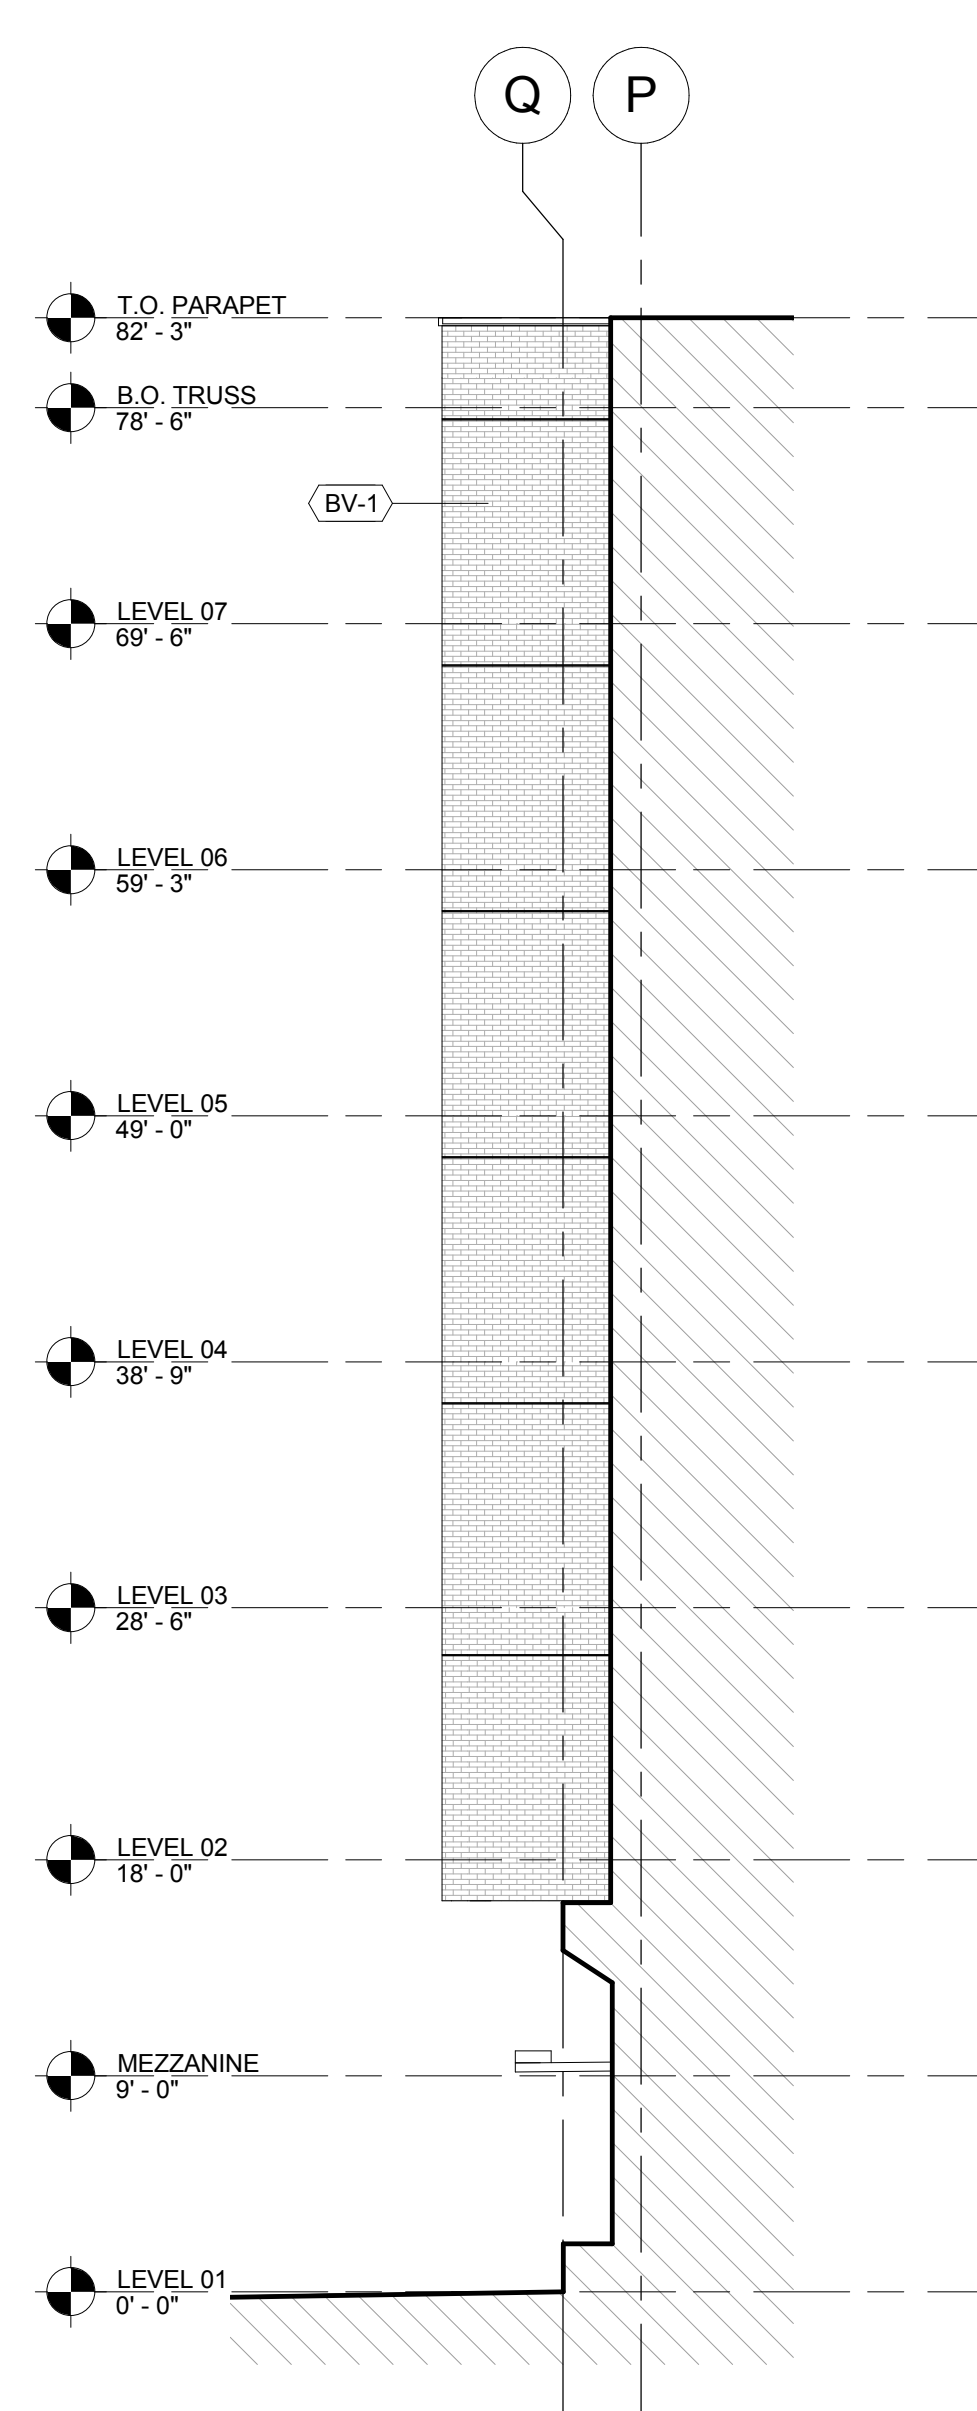

3 EAST ELEVATION AT NORTH CORRIDOR INSET
A2.02 1/8" = 1'-0"

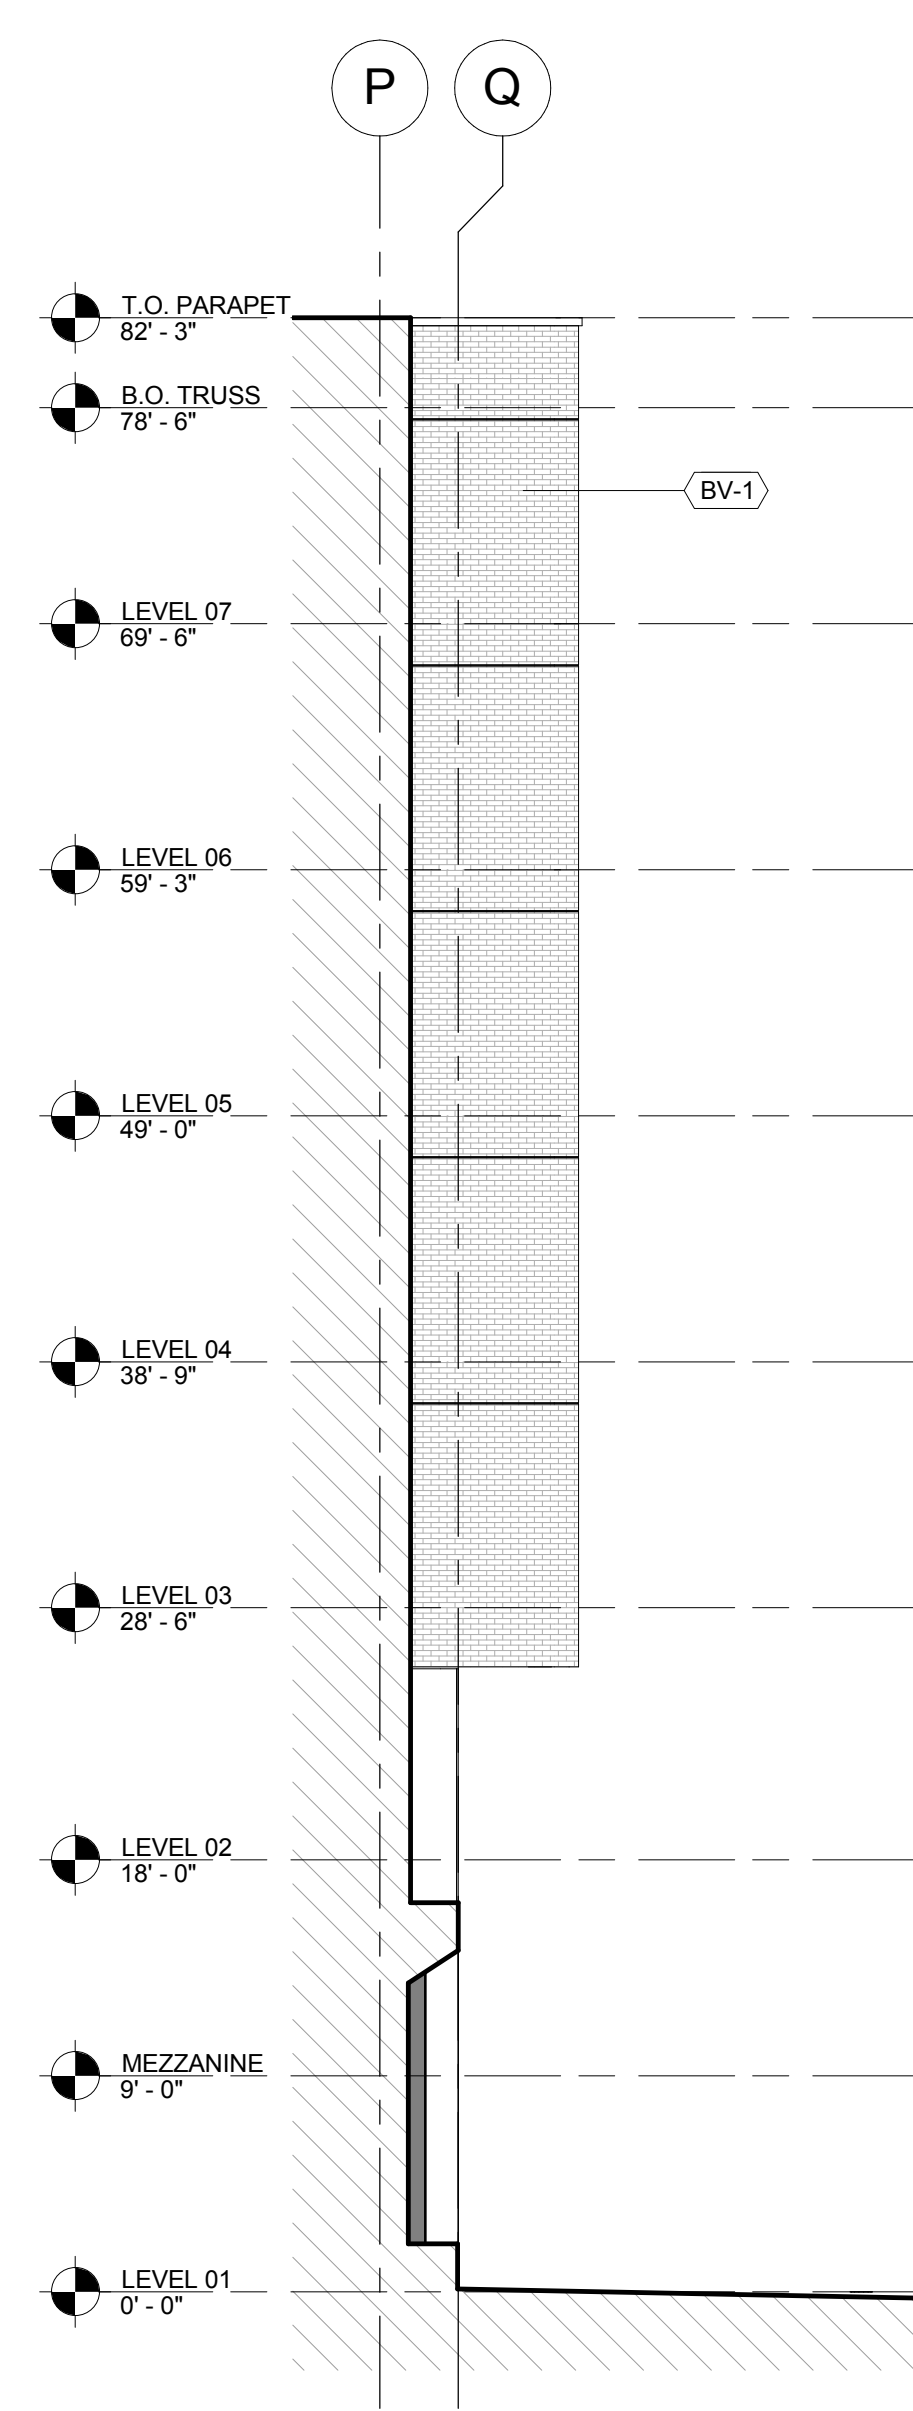


2 WEST ELEVATION AT NORTH CORRIDOR INSET
A2.02 1/8" = 1'-0"

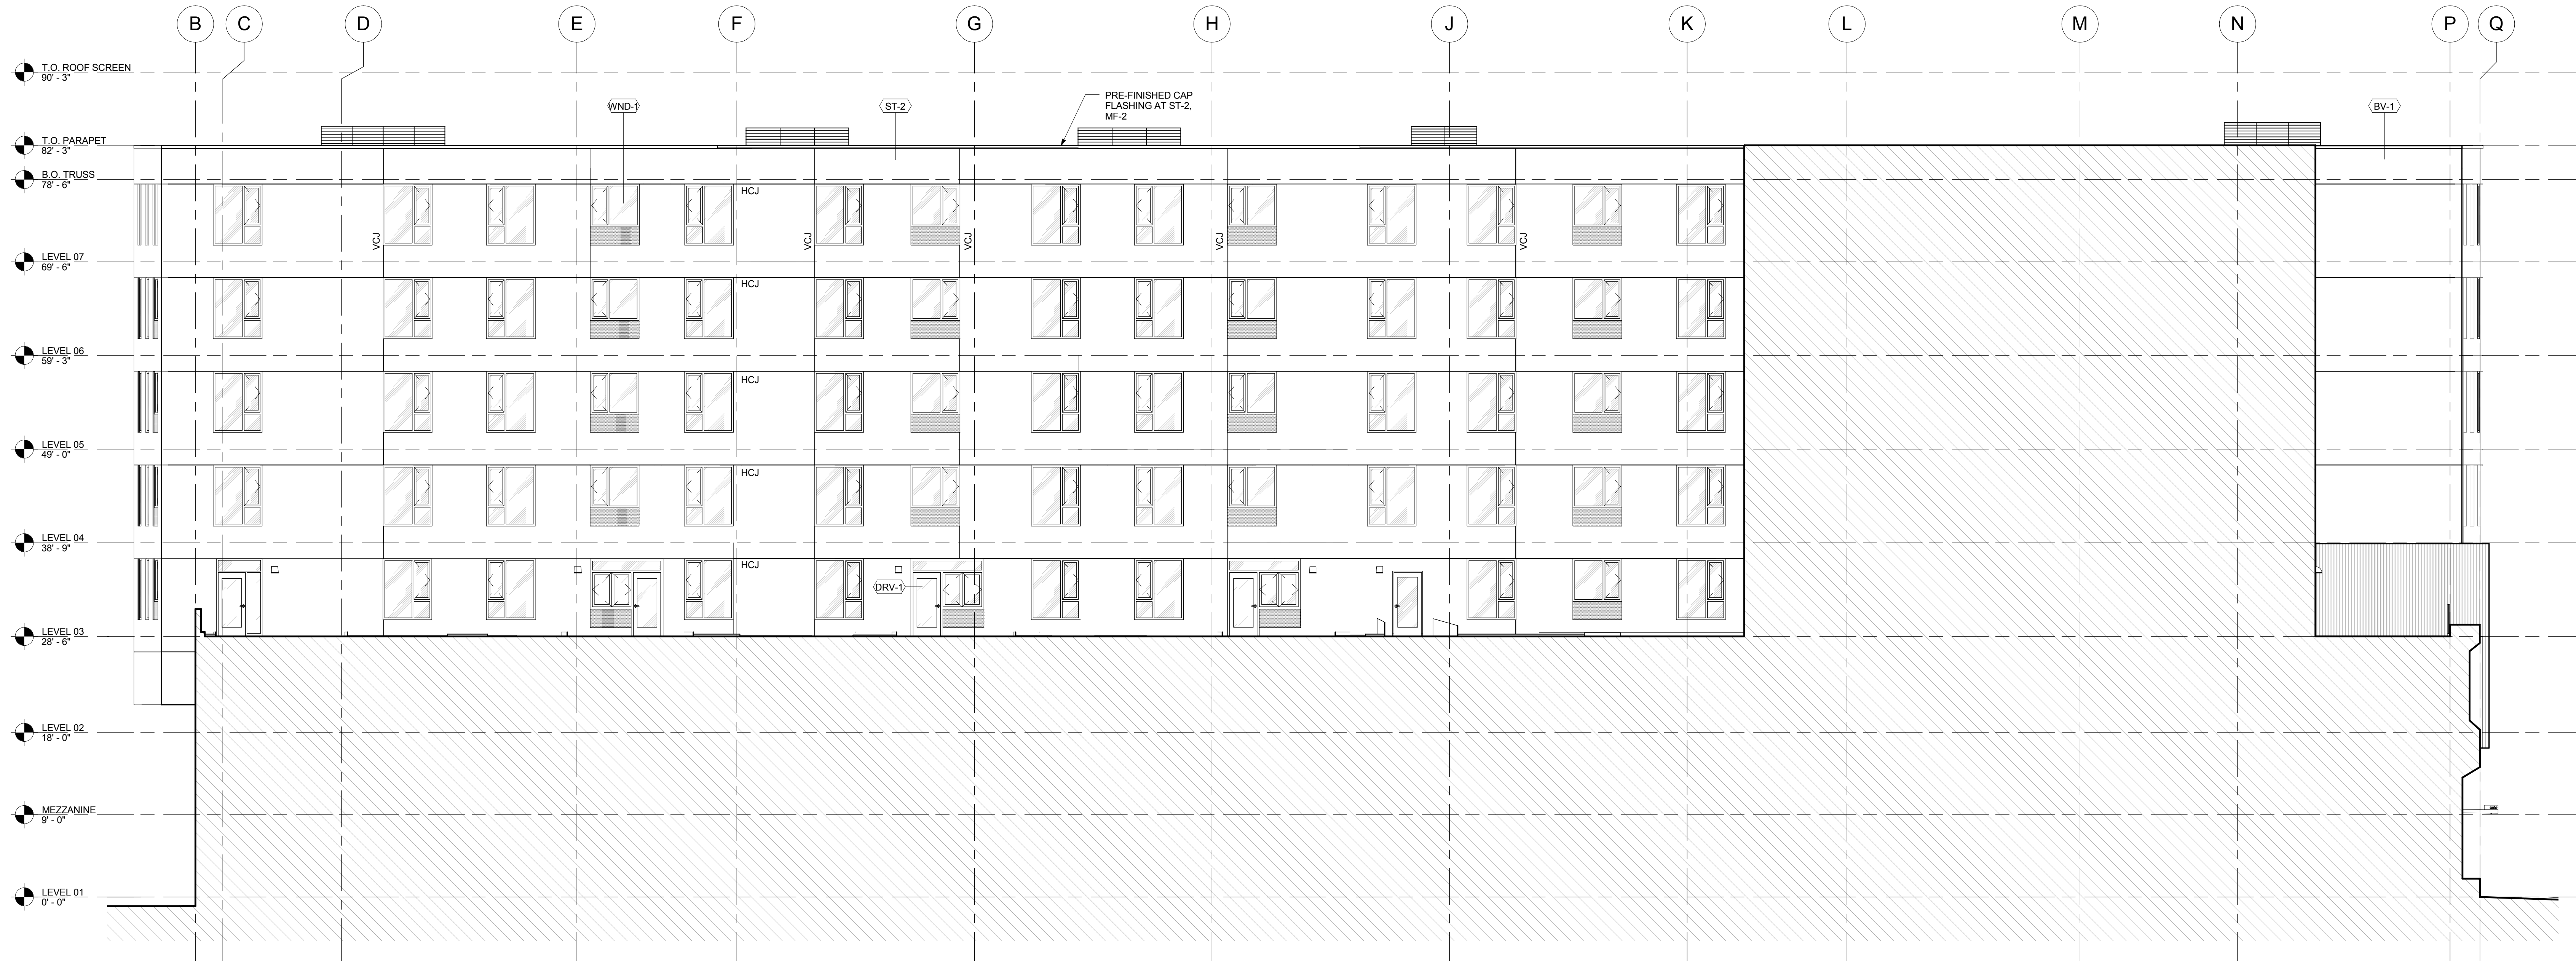

1 WEST COURTYARD ELEVATION
A2.02 1/8" = 1'-0"

MATERIAL LEGEND / NOTES

- ST-1 INTEGRAL COLOR ACRYLIC STUCCO, WITH CUSTOM TEXTURE FINISH, CUSTOM COLOR
- ST-2 "FREESTYLE" SMOOTH FINISH, INTEGRAL COLOR ACRYLIC STUCCO, CUSTOM COLOR
- ST-3 "FREESTYLE" SMOOTH FINISH, INTEGRAL COLOR ACRYLIC STUCCO, STANDARD WHITE
- MP-1 PRE-FINISHED KYMAR COATED ALUMINUM WALL PANEL
- MP-1.2 PRE-FINISHED KYMAR COATED ALUMINUM WALL PANEL, PERFORATED
- MP-2 PAINTED 1/4" STEEL PLATE OVER HSS FRAME
- SF-1 ALUMINUM STOREFRONT, SSG (STRUCTURAL SILICONE GLAZED VERTICALS), PAINTED KYMAR FINISH
- BV-1 BRICK VENEER
- DRV-1 COMMERCIAL GRADE, FACTORY MULLED VINYL SWING DOOR W/ SIDELITE & TRANSOM
- WND-1 COMMERCIAL GRADE VINYL WINDOW
- WND-2 THERMAL ALUMINUM GLASS VENT FOR STOREFRONT
- MF-1 20 GA PRE-FINISHED METAL FLASHING T/M MP-1
- MF-2 20 GA PRE-FINISHED METAL FLASHING T/M ST-2
- MS-1 PERFORATED ALUMINUM "V" PANEL, PRE-FINISHED KYMAR PAINTED, STANDARD WHITE
- MS-2 PERFORATED STEEL PLATE, PRE-FINISHED KYMAR PAINTED, STANDARD WHITE
- T TEMPERED GLASS
- VCJ VERTICAL CONTROL JOINT
- HCJ HORIZONTAL CONTROL JOINT, TYPICAL AT EACH WND-1 HEAD

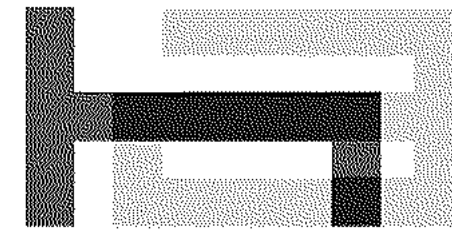

Holist Architecture

110 SE 8th Ave
Portland, OR 97214
www.holistarc.com

5TH & BROAD

401 S 5TH ST
BOISE, ID 83702

JOB NO. 14-111

CONSTRUCTION DOCUMENTS

issue:	date:
100% SD	04.14.15
PODIUM PERMIT	06.12.15
100% DD	07.09.15
50% CD	08.20.15
60% CD	09.08.15
75% CD PERMIT	09.18.15

revision list date:

sheet title:






EXTERIOR
BUILDING
ELEVATIONS

sheet no.:

A2.02


© 2012 HOLST ARCHITECTURE pc

12/7/2015 12:21:38 PM

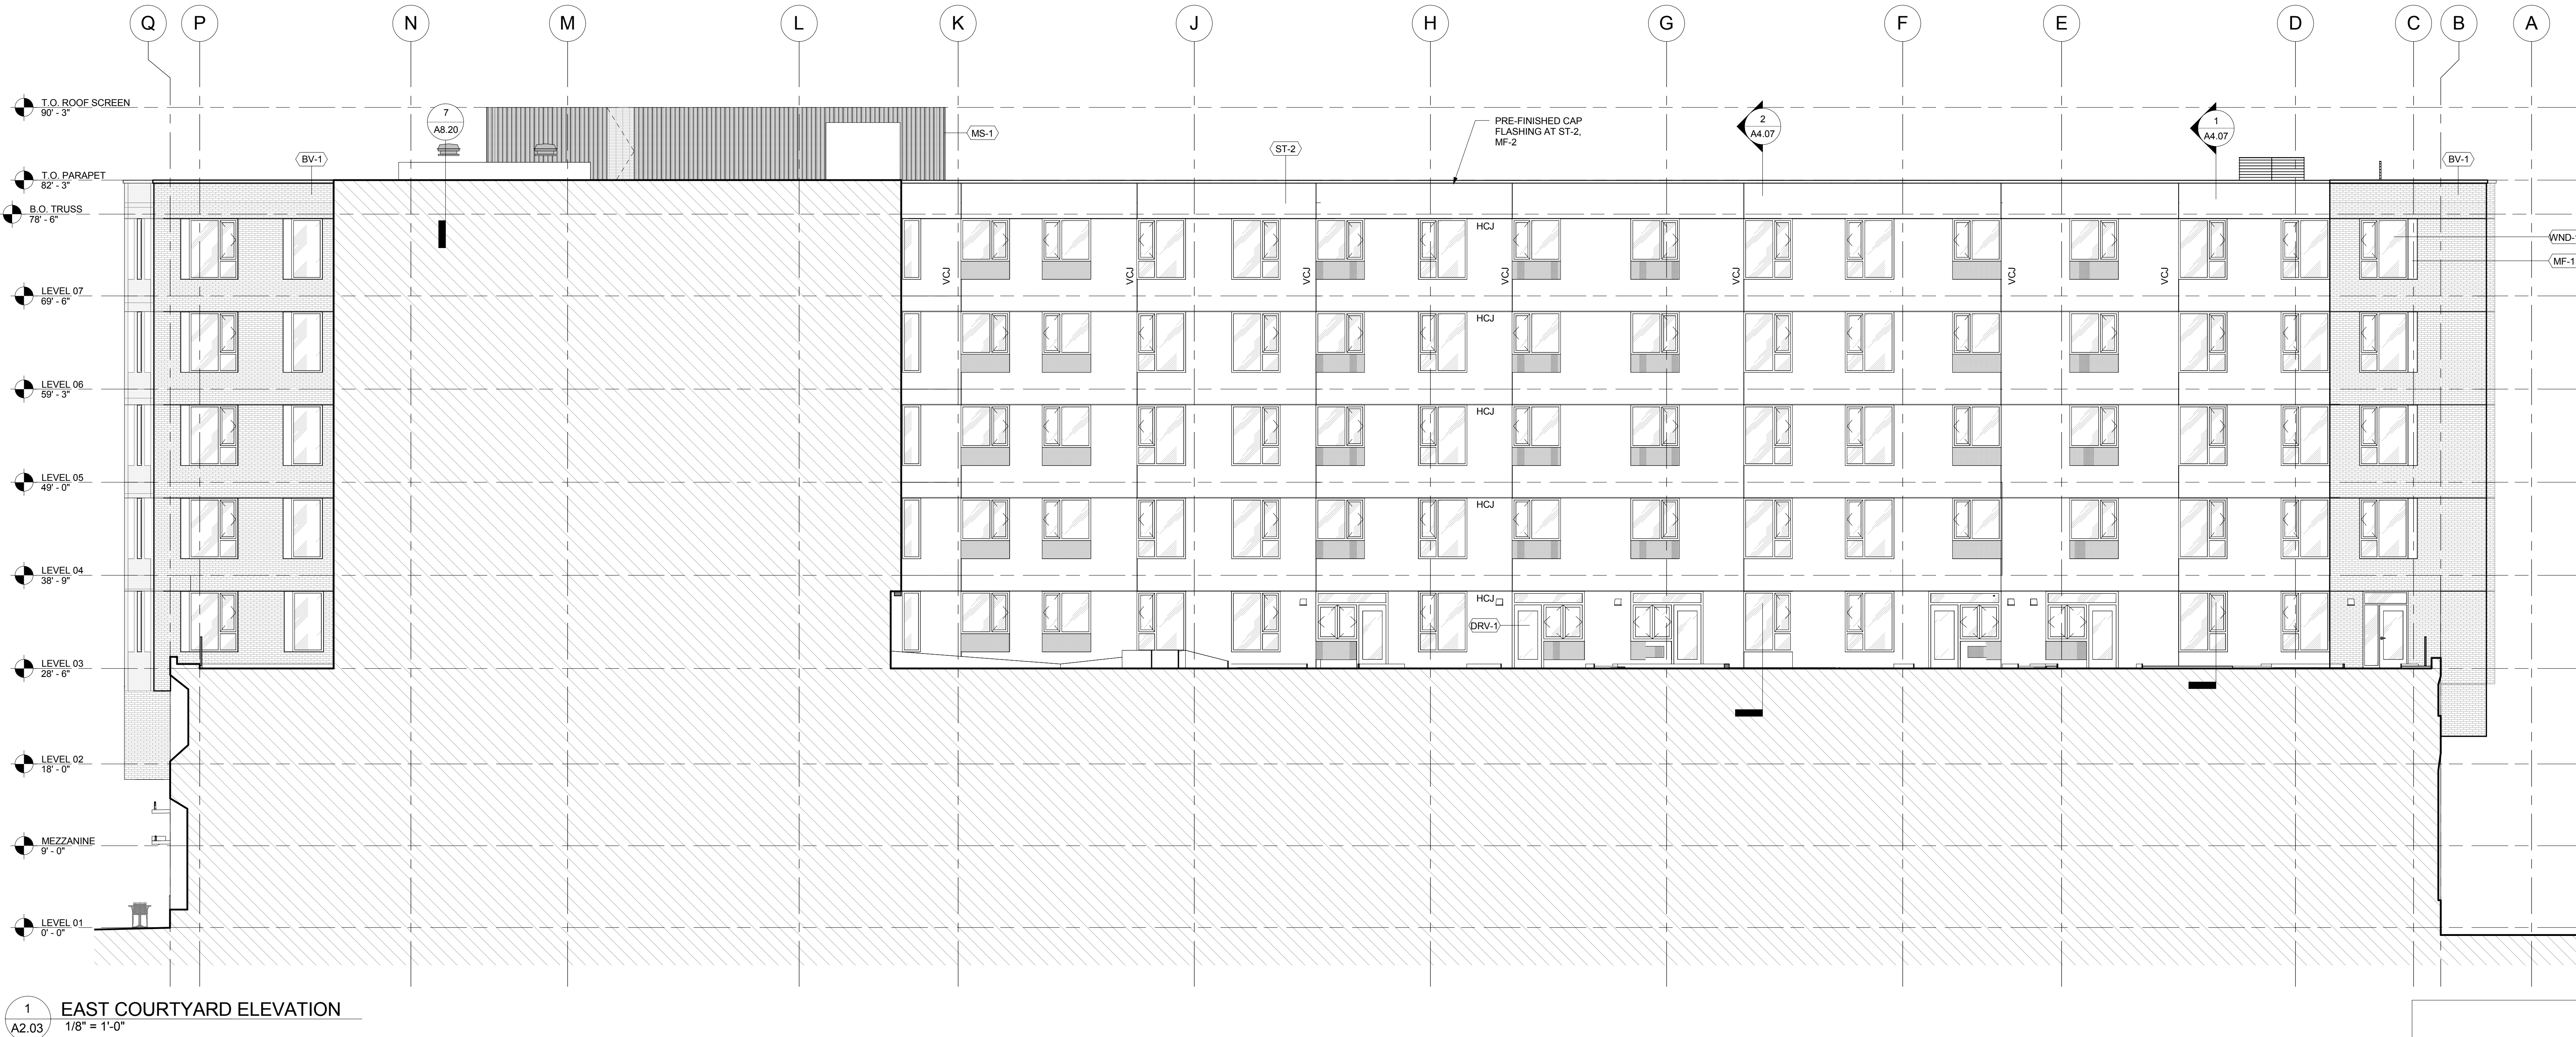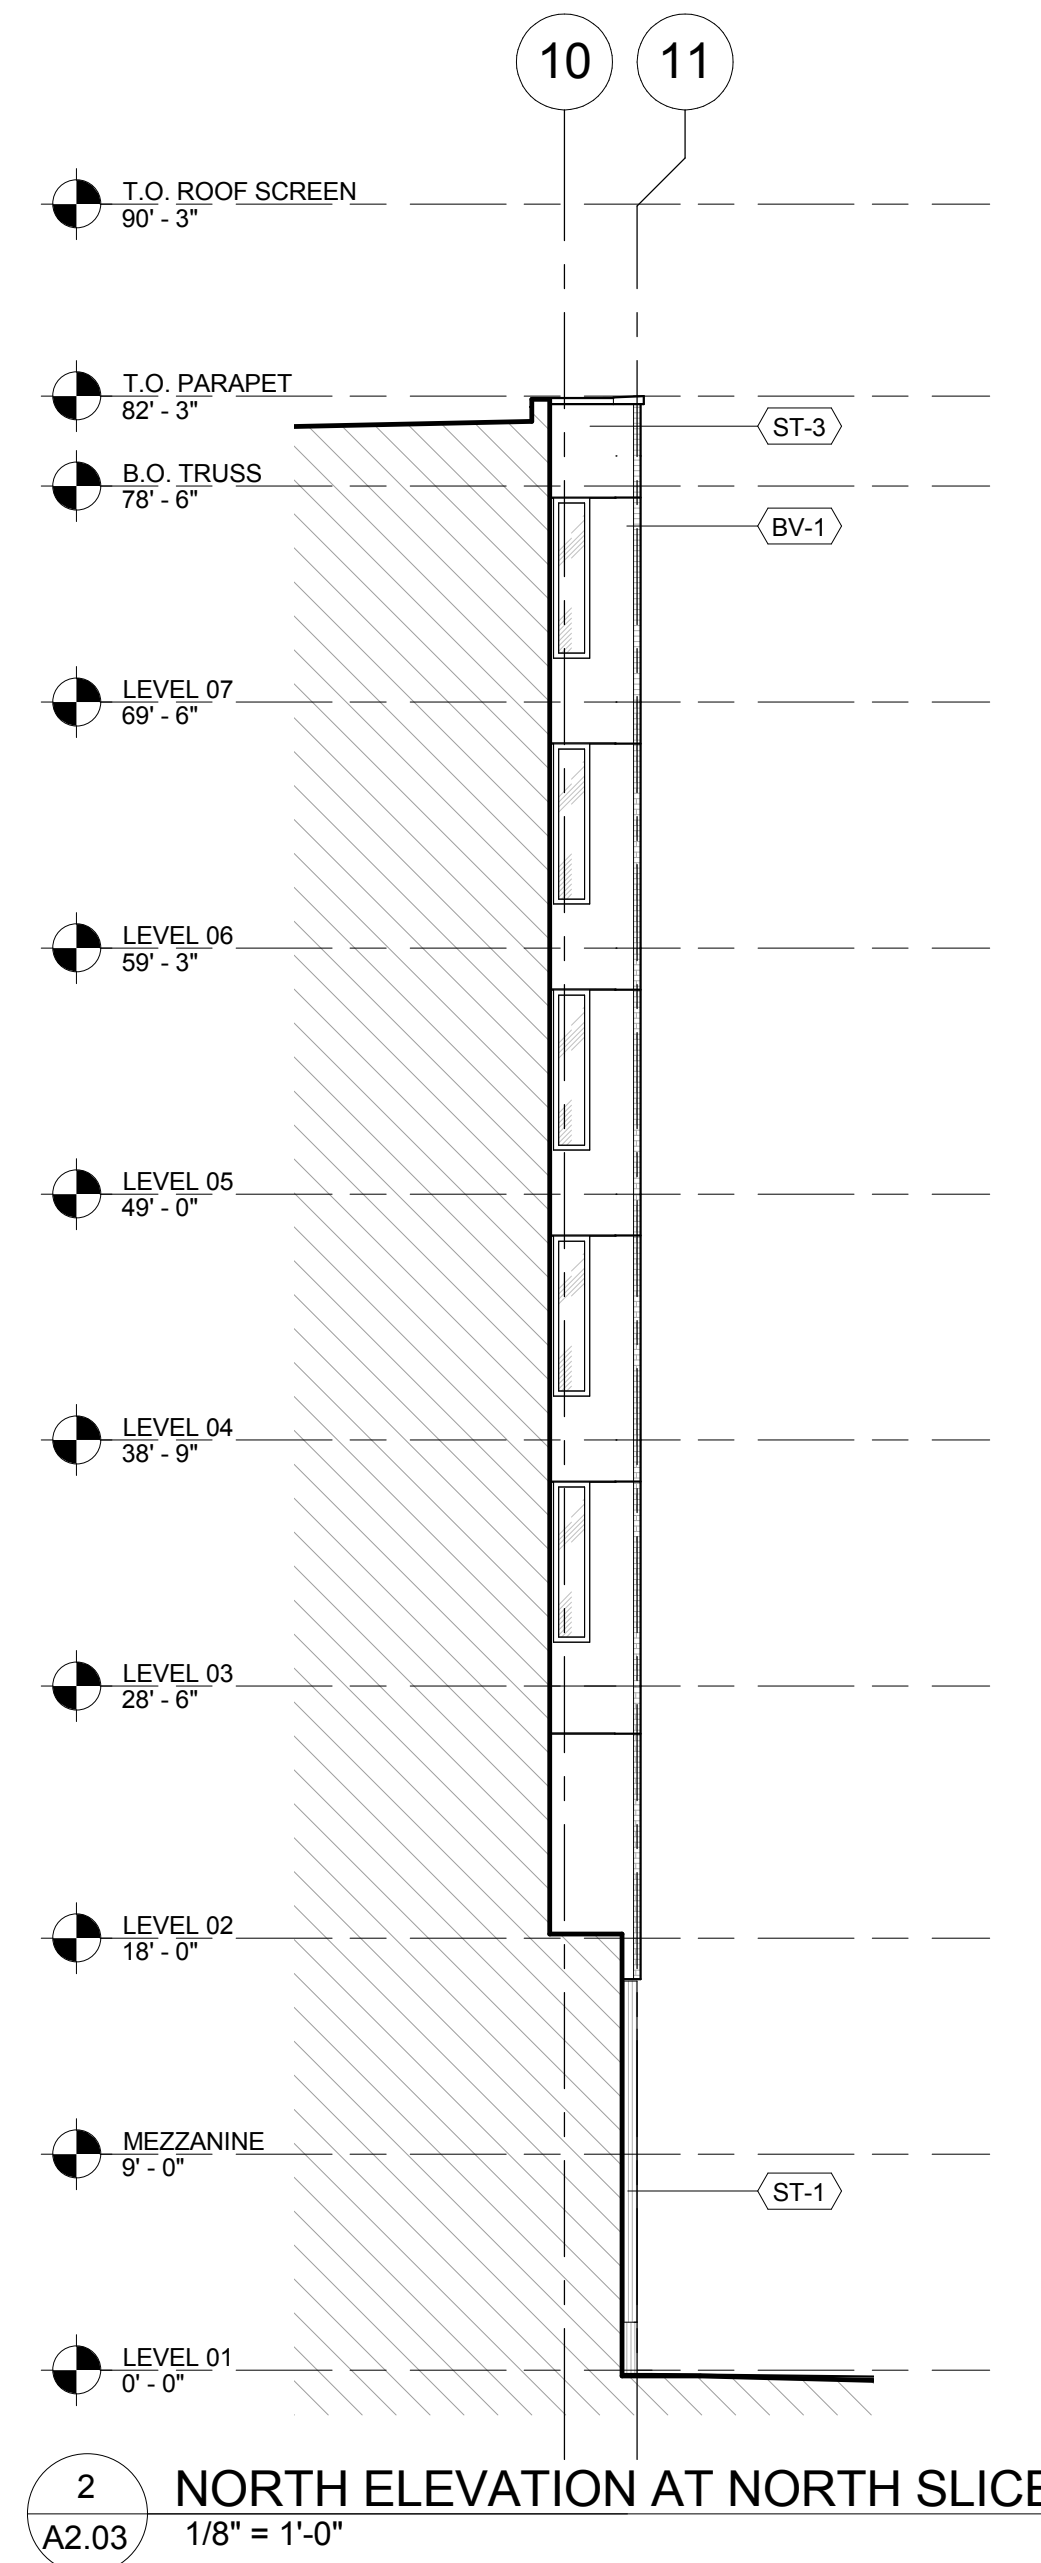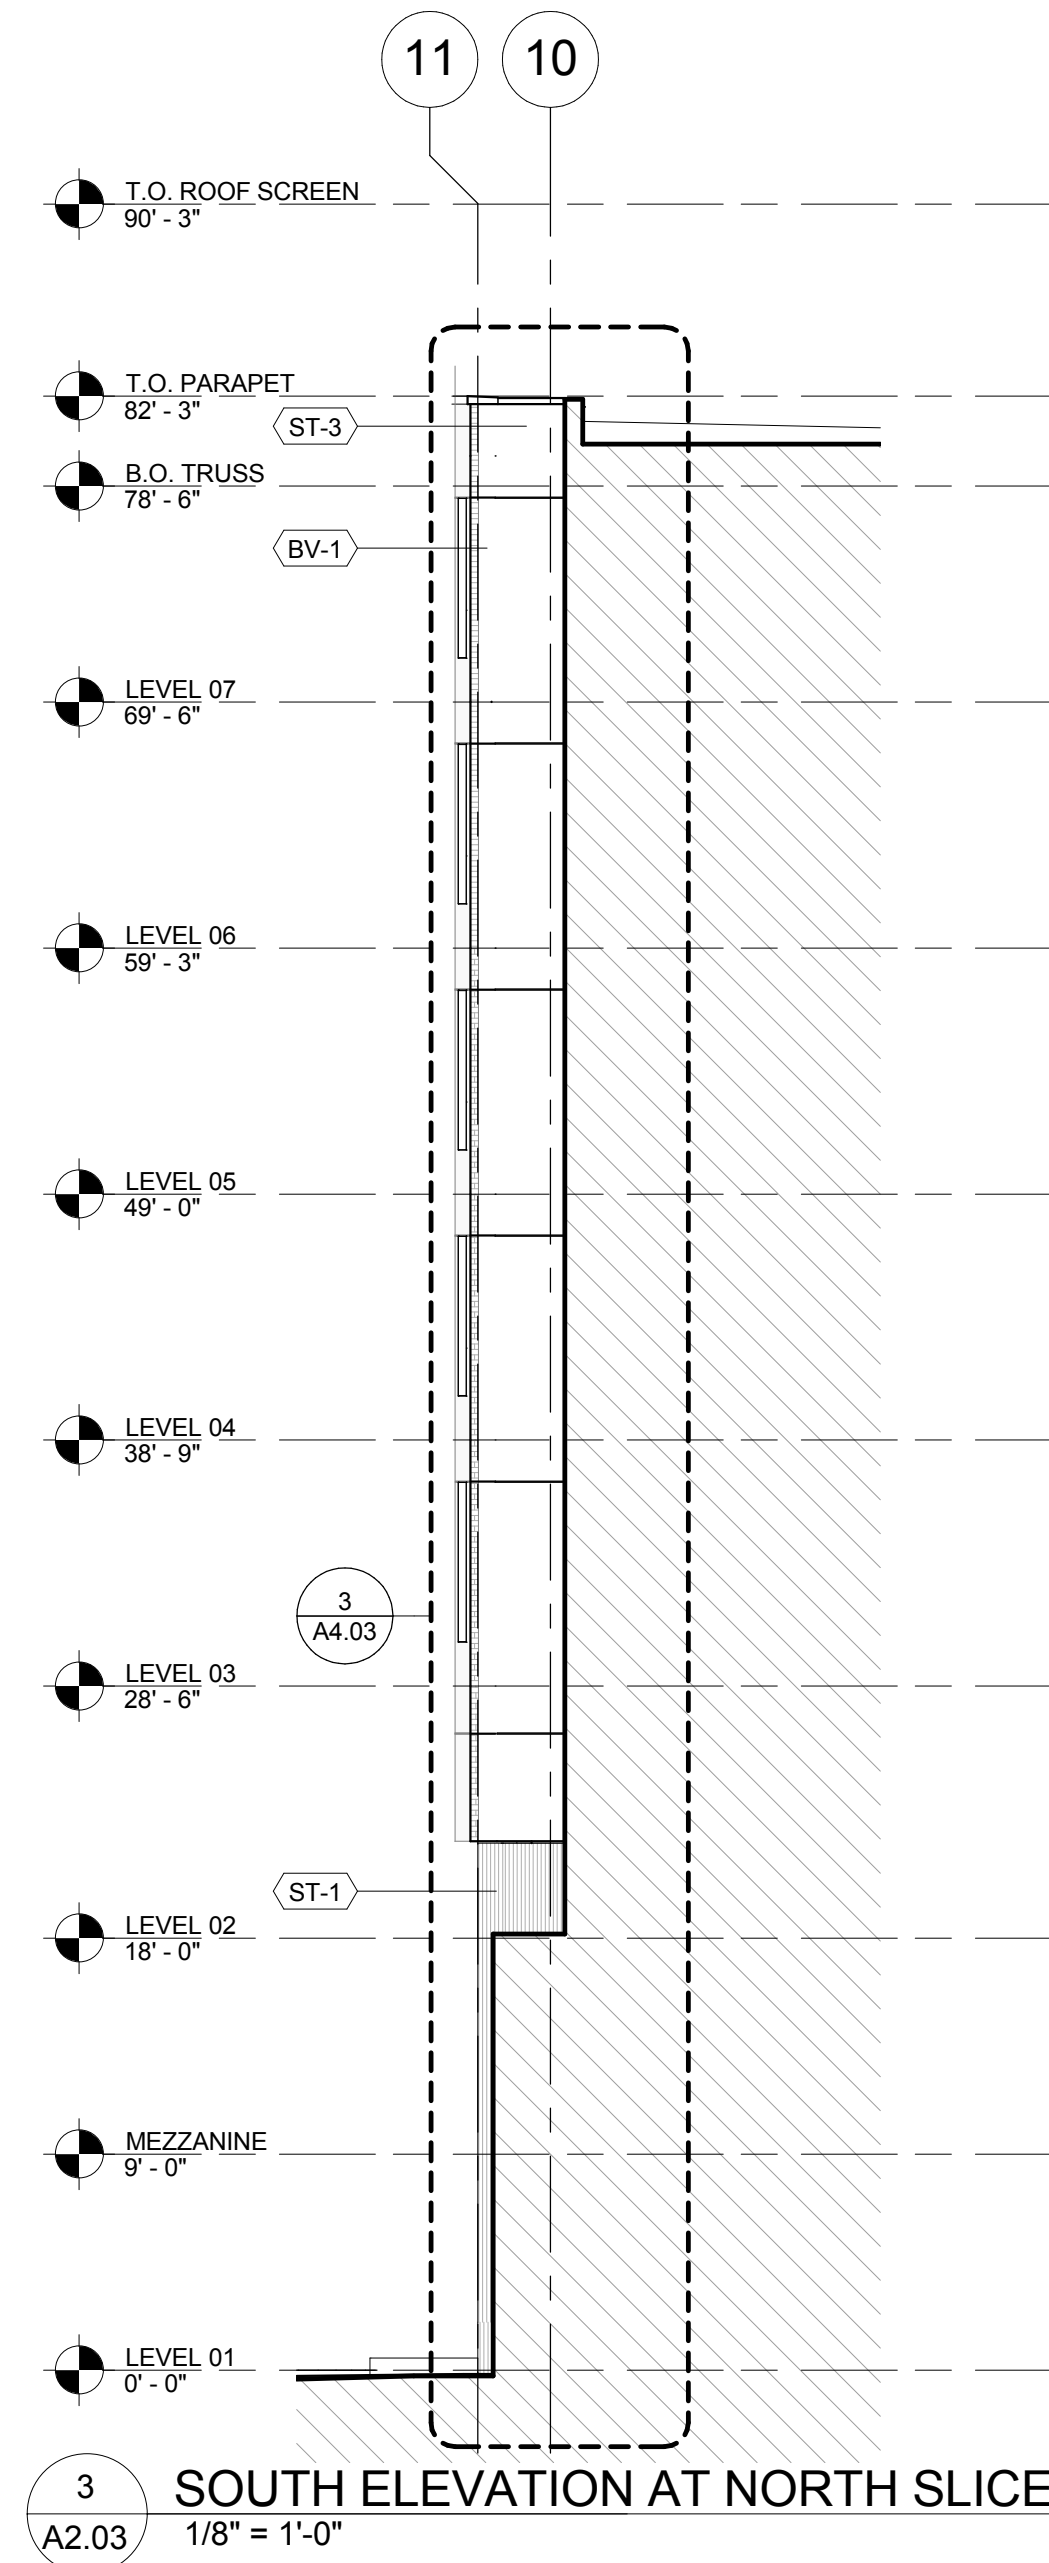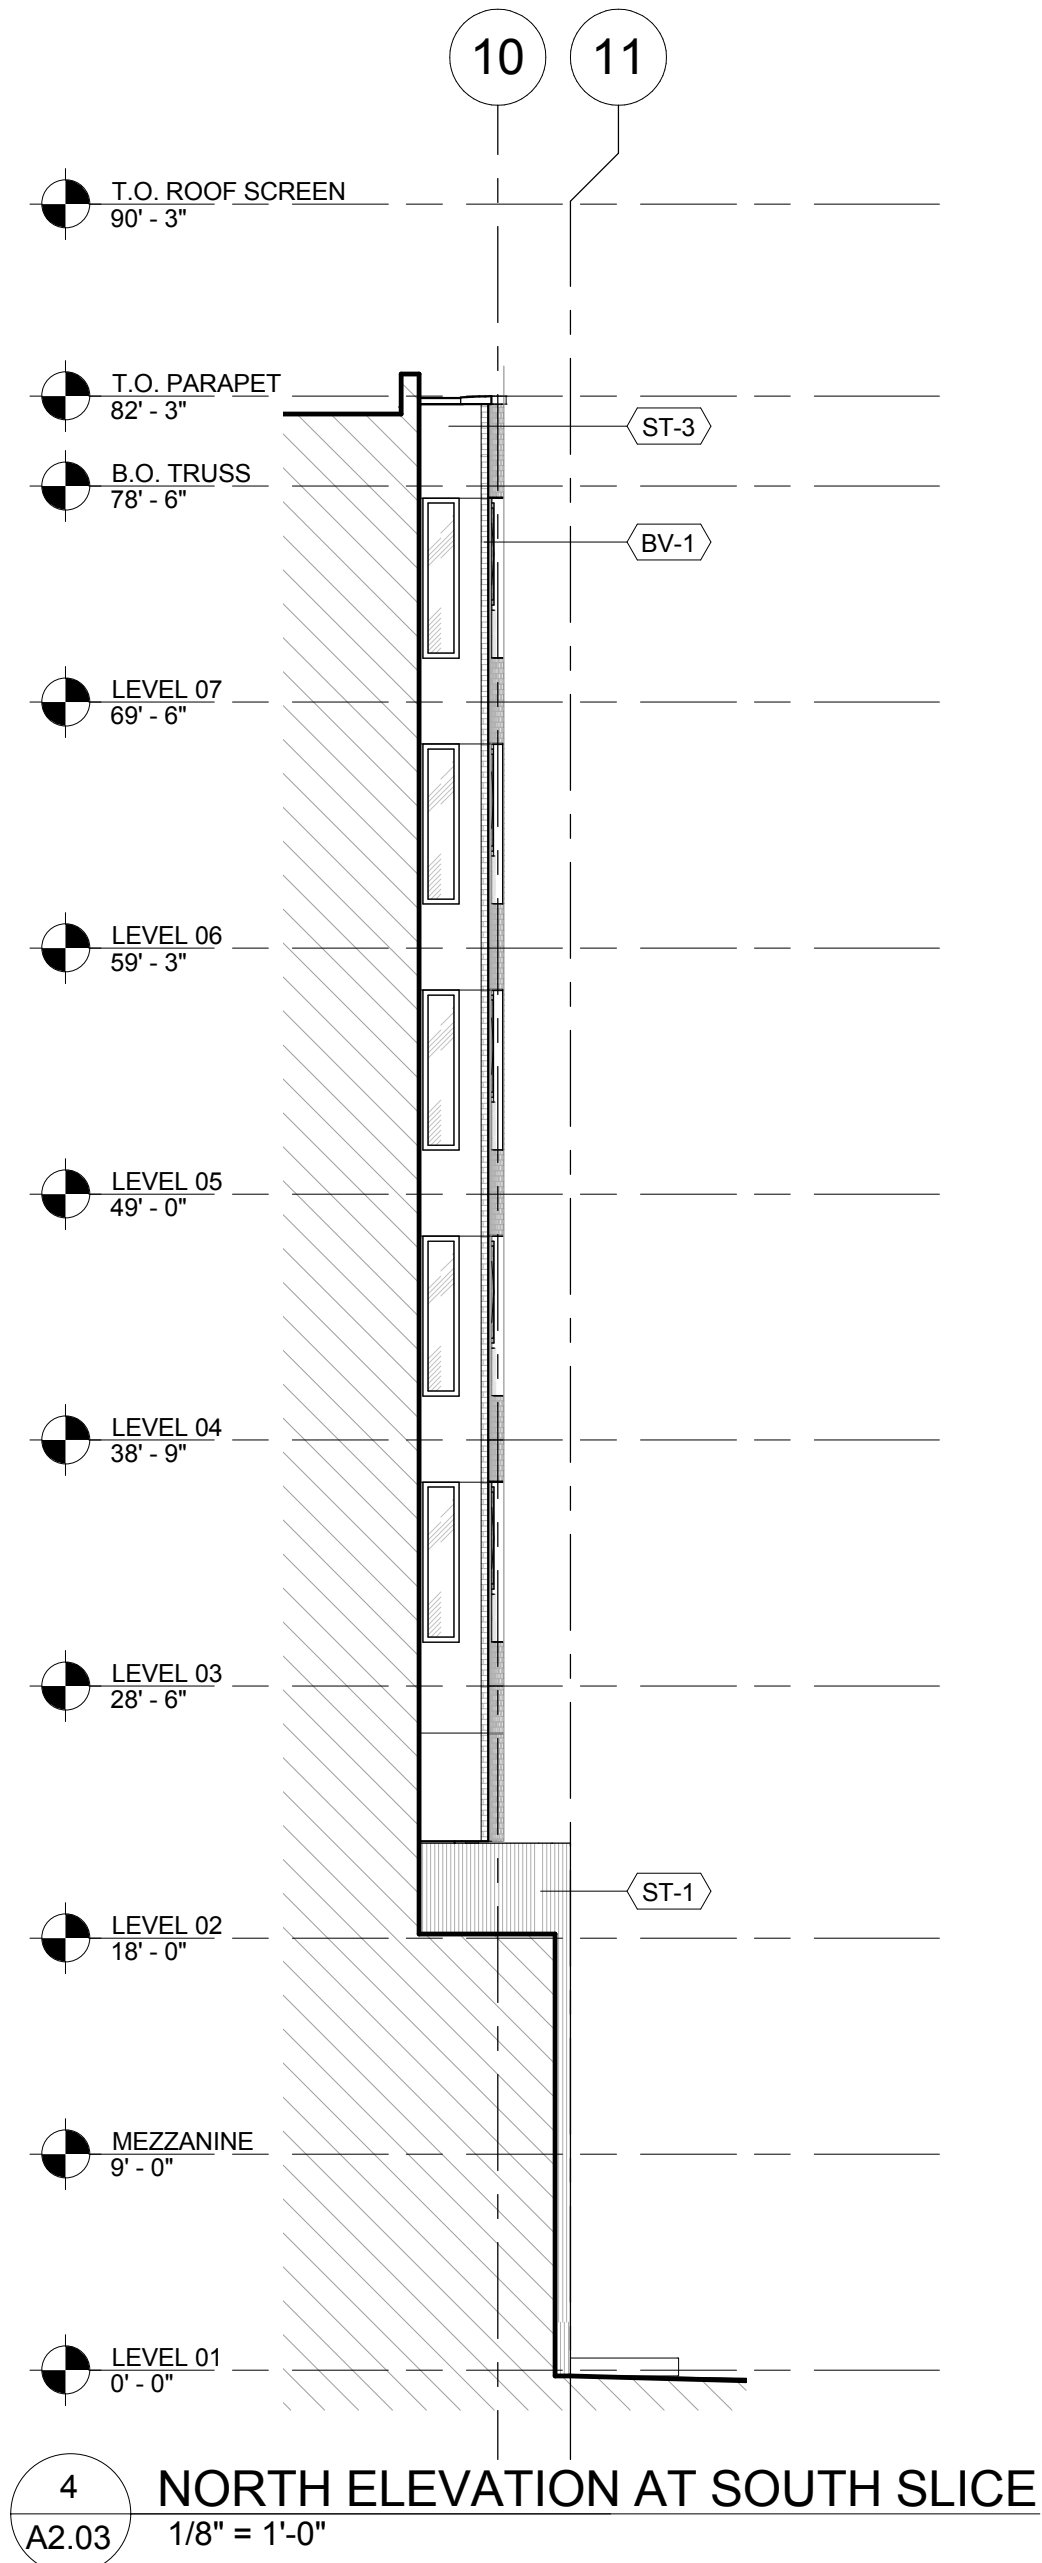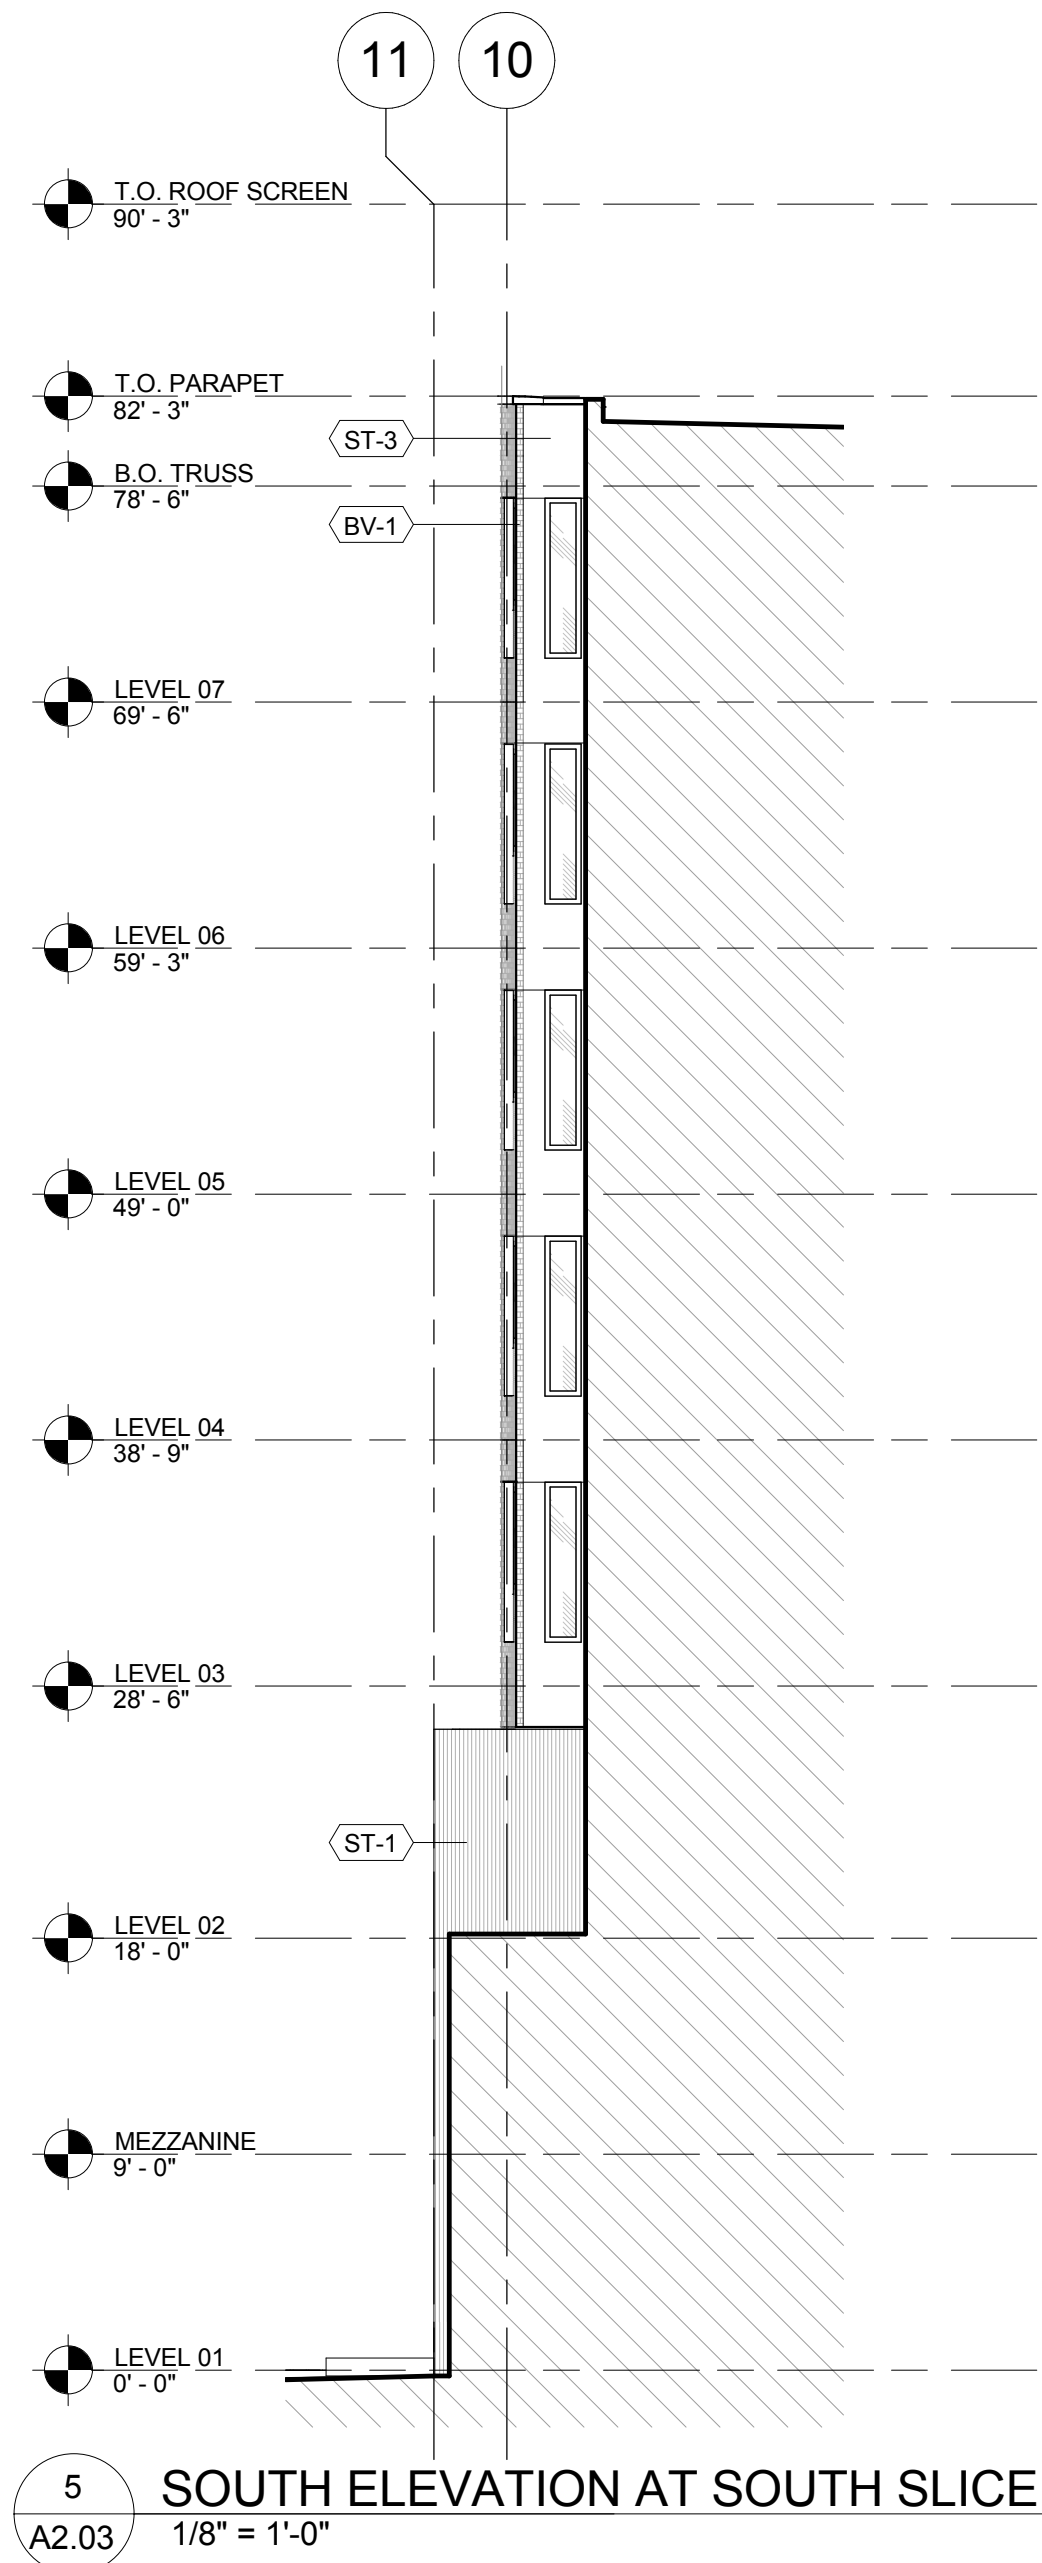

MATERIAL LEGEND / NOTES

- ST-1 INTEGRAL COLOR ACRYLIC STUCCO, WITH CUSTOM TEXTURE FINISH, CUSTOM COLOR
- ST-2 "FREESTYLE" SMOOTH FINISH, INTEGRAL COLOR ACRYLIC STUCCO, CUSTOM COLOR
- ST-3 "FREESTYLE" SMOOTH FINISH, INTEGRAL COLOR ACRYLIC STUCCO, STANDARD WHITE
- MP-1 PRE-FINISHED KYNAR COATED ALUMINUM WALL PANEL
- MP-1.2 PRE-FINISHED KYNAR COATED ALUMINUM WALL PANEL, PERFORATED
- MP-2 PAINTED 1/4" STEEL PLATE OVER HSS FRAME
- SF-1 ALUMINUM STOREFRONT, SSG (STRUCTURAL SILICONE GLAZED VERTICALS), PAINTED KYNAR FINISH
- BV-1 BRICK VENEER
- DRV-1 COMMERCIAL GRADE, FACTORY MULLED VINYL SWING DOOR W/ SIDELITE & TRANSOM
- WND-1 COMMERCIAL GRADE VINYL WINDOW
- WND-2 THERMAL ALUMINUM GLASS VENT FOR STOREFRONT
- MF-1 20 GA PRE-FINISHED METAL FLASHING T/M MP-1
- MF-2 20 GA PRE-FINISHED METAL FLASHING T/M ST-2
- MS-1 PERFORATED ALUMINUM "V" PANEL, PRE-FINISHED KYNAR PAINTED, STANDARD WHITE
- MS-2 PERFORATED STEEL PLATE, PRE-FINISHED KYNAR PAINTED, STANDARD WHITE
- T TEMPERED GLASS
- VCJ VERTICAL CONTROL JOINT
- HCJ HORIZONTAL CONTROL JOINT, TYPICAL AT EACH WND-1 HEAD

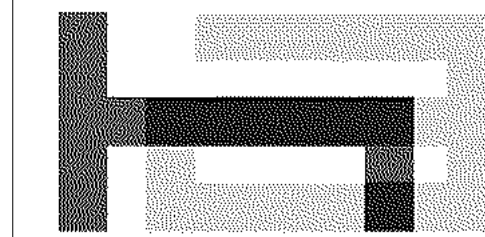

Holst Architecture

110 SE 8th Ave
Portland, OR 97214
www.holstarc.com

5TH & BROAD

401 S 5TH ST
BOISE, ID 83702

JOB NO. 14-111

CONSTRUCTION DOCUMENTS

issue:	date:
100% SD	04.14.15
PODIUM PERMIT	06.12.15
100% DD	07.09.15
50% CD	08.20.15
60% CD	09.08.15
75% CD PERMIT	09.18.15

revision list date:

sheet title:

EXTERIOR
BUILDING
ELEVATIONS

sheet no.:

A2.03

© 2012 HOLST ARCHITECTURE pc